

w/H n-56t
2 641
3 621
3 659
7-7

REEF DISPENSARIES TENANT IMPROVEMENT

1930 WEST E AVE BLDG. 621
TOOELE, UTAH 84074

ENGINEER:



PROJECT MANAGER: JACOB CLEGG, PE
ENGINEER: JACOB CLEGG, PE

TOOELE
169 N. Main Street, Unit 1
Tooele, UT 84074
Phone: 435.843.3590
Fax: 435.578.0168
WWW.ENSIGNENG.COM

SALT LAKE CITY
Phone: 801.255.0529

LAYTON
Phone: 801.547.1100

CEDAR CITY
Phone: 435.865.1453


RICHFIELD
Phone: 435.896.2983

DATE PRINTED
June 26, 2019

CONSULTANTS

DESIGNER/STRUCTURAL ENGINEERS:
ENSIGN ENGINEERING
JACOB CLEGG, PE
169 NORTH MAIN STREET SUITE 1
TOOELE, UTAH 84074
435-843-3590
JCLEGG@ENSIGNUTAH.COM

VICINITY MAP

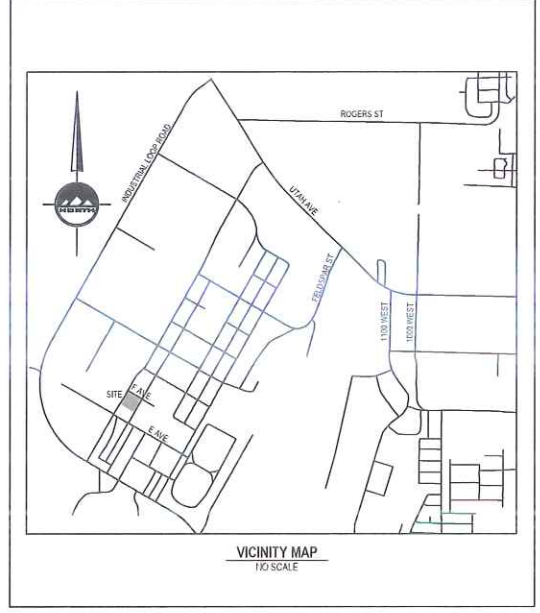

SHEET INDEX

A1.0	FLOOR PLAN
A1.1	SECURITY FLOOR PLAN
A2.0	REFLECTIVE CEILING PLAN
A3.0	DETAILS
S1.0	DOCK FOUNDATION PLAN
E0.0	ELECTRICAL COVER SHEET
E2.1	LIGHTING PLAN
E3.1	POWER PLAN
E6.1	ELECTRICAL SCHEDULES
E7.1	ELECTRICAL DETAILS
E7.2	ELECTRICAL DETAILS
E8.1	ELECTRICAL SPECIFICATIONS



TOOELE
169 N. Main Street, Unit 1
Tooele, UT 84074
Phone: 435.843.3590

SALT LAKE CITY
Phone: 801.255.0529

LAYTON
Phone: 801.547.1100

CEDAR CITY
Phone: 435.865.1453

RICHFIELD
Phone: 435.896.2983

WWW.ENSIGNENG.COM

FOR:
REEF DISPENSARIES
3400 WESTERN AVE
LAS VEGAS, NEVADA 89109

CONTACT:
STEVE VANMEETREN
PHONE: 800-908-6510 EXT. 222

REEF DISPENSARIES
TENANT IMPROVEMENT
1930 WEST E AVE BLDG 621
TOOELE, UTAH 84074

REVIEW SET

COVER

PROJECT NUMBER: 5147
PROJECT DATE: 6/26/19
DRAWN BY: D. PETERSEN
CHECKED BY: J. CLEGG
PROJECT MANAGER: J. CLEGG

**REEF DISPENSARIES
TENANT IMPROVEMENT**
1930 WEST E AVE BLDG 621
TOOELE, UTAH 84074

REVIEW SET

FLOOR PLAN

PROJECT NUMBER
5147


PROJ DATE
6/25/19

DRAWN BY
D. PETERSEN

CHECKED BY
J. CLEGG

PROJECT MANAGER
J. CLEGG

A1.0

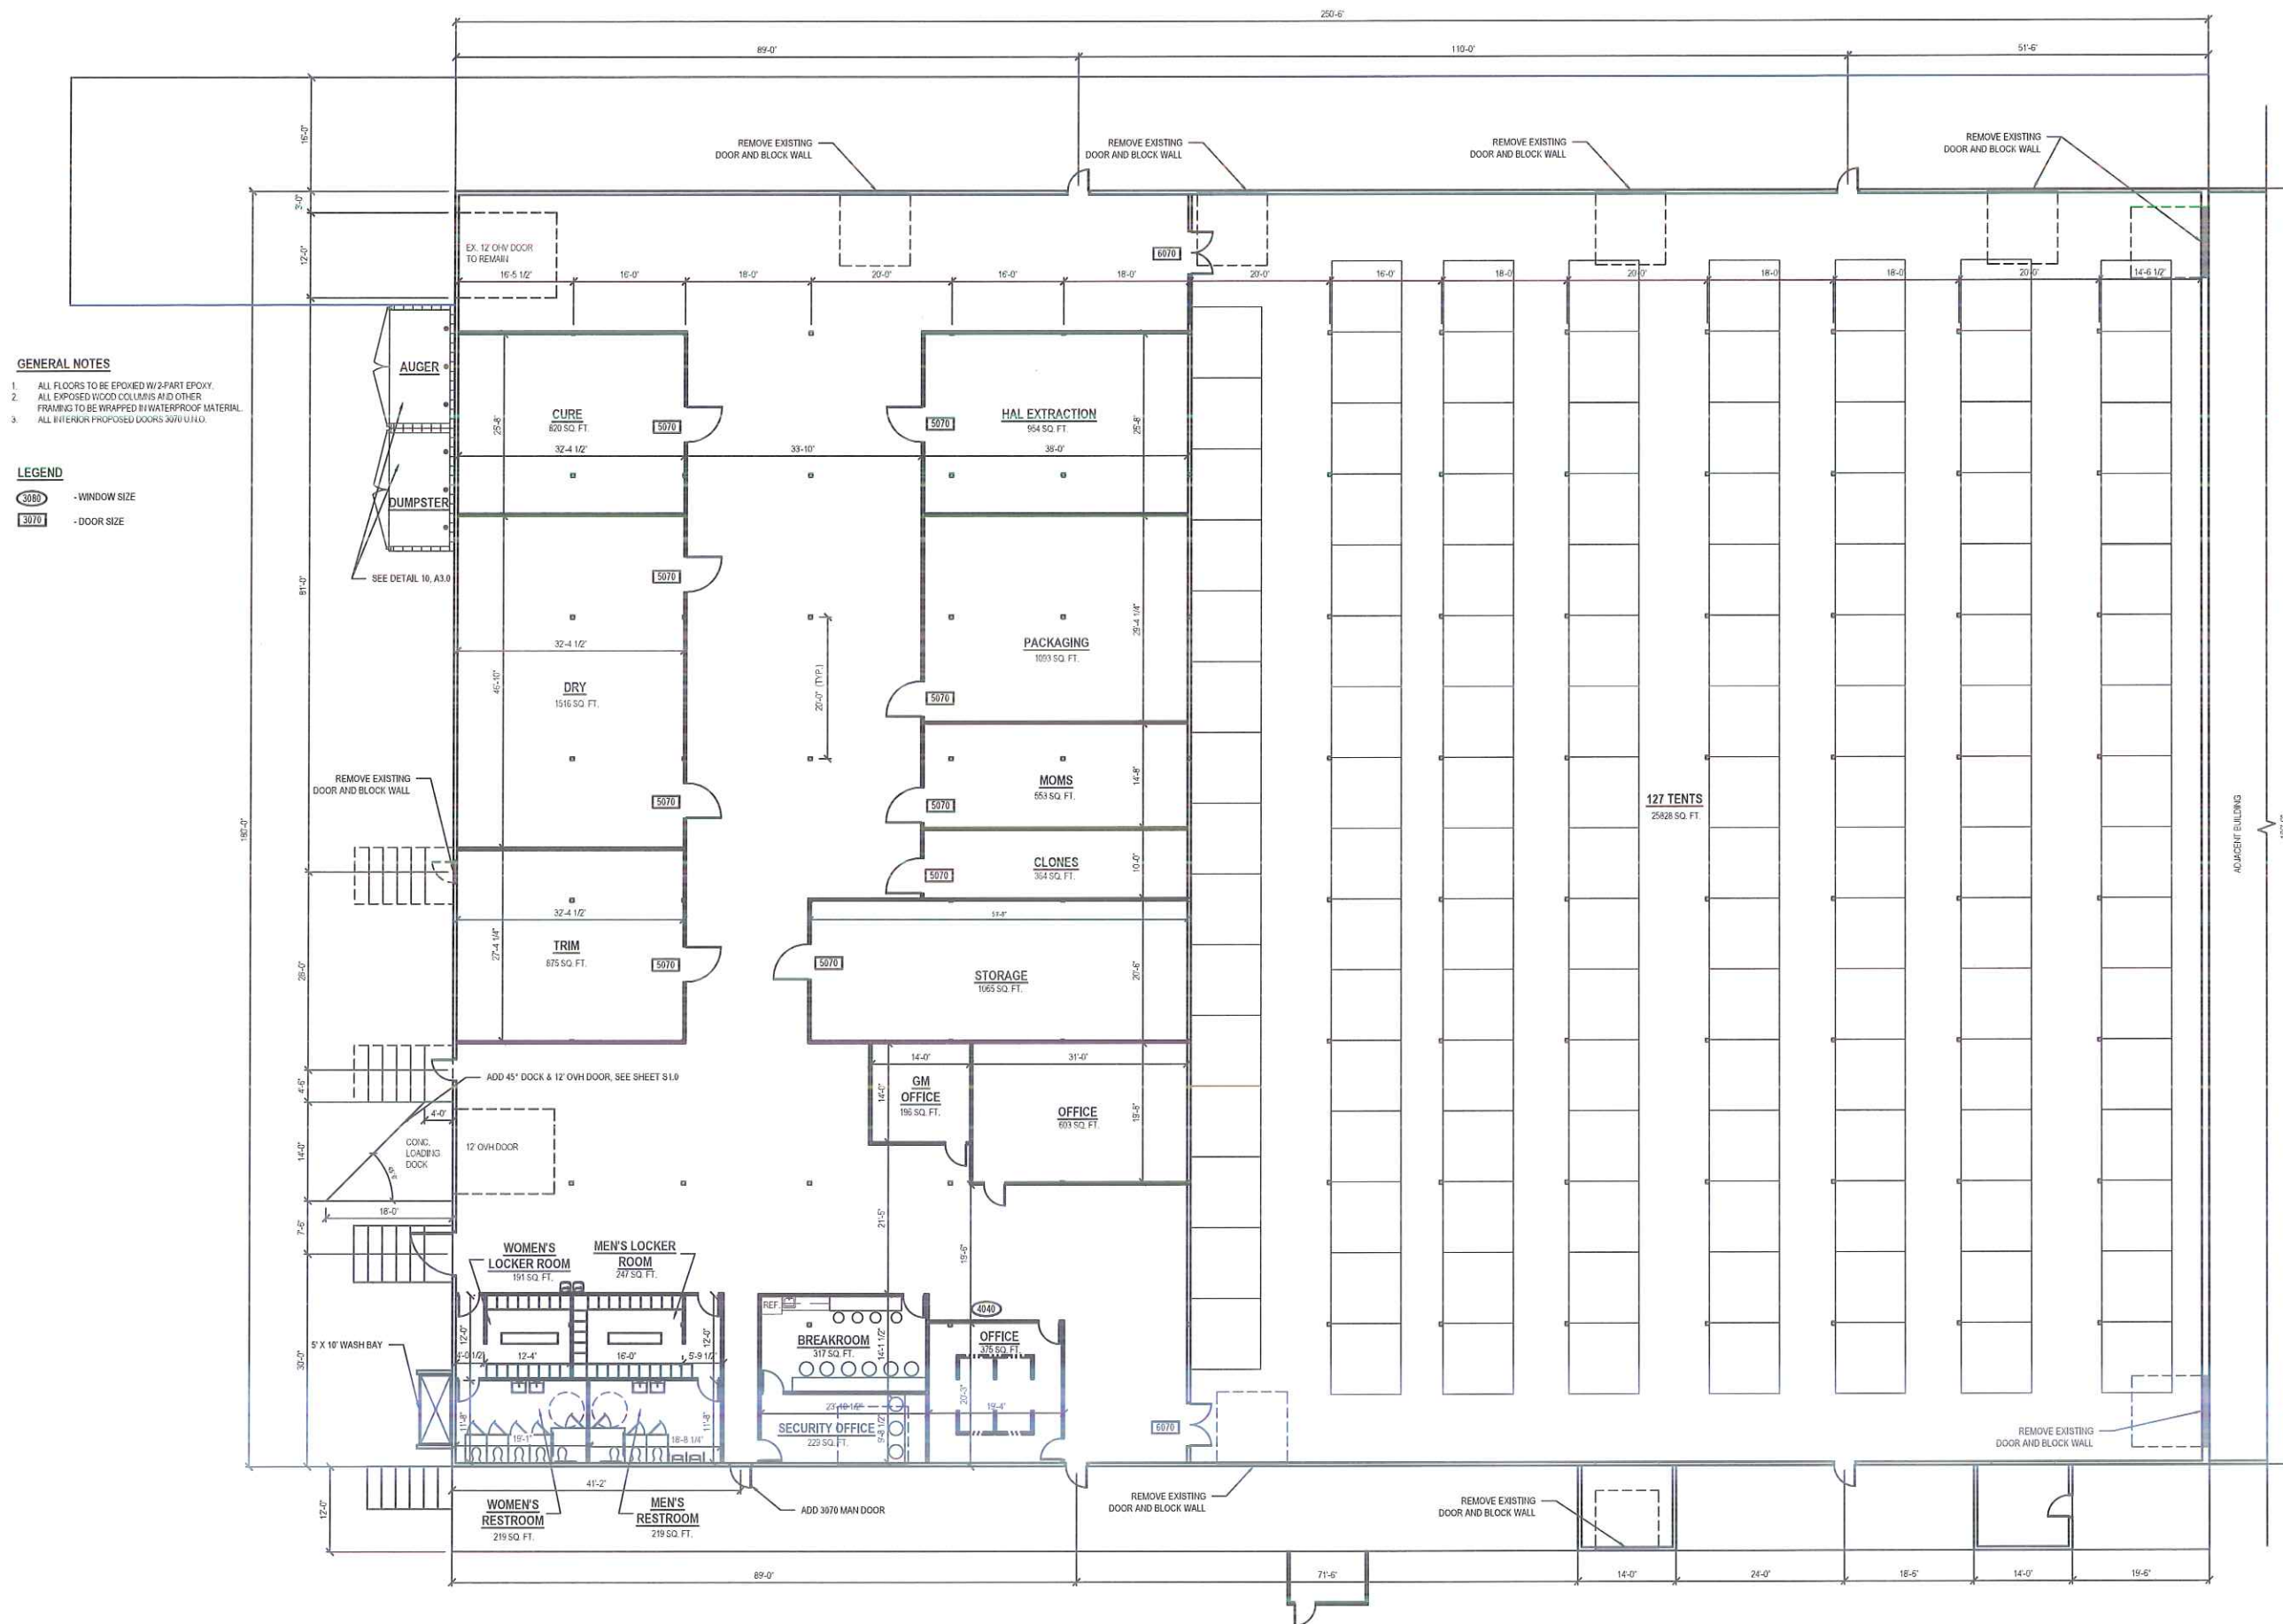



ENSIGN
THE STANDARD IN ENGINEERING

TOOELE
169 N. Main Street, Unit 1
Tooele, UT, 84074
Phone: 435.843.3590

SALT LAKE CITY
Phone: 801.255.0529

LAYTON
Phone: 801.547.1100

CEDAR CITY
Phone: 435.865.1453

RICHFIELD
Phone: 435.896.2983

WWW.ENSIGNENG.COM

FOR:
REEF DISPENSARIES
3400 WESTERN AVE
LAS VEGAS, NEVADA 89109

CONTACT:
STEVE VANMEETREN
PHONE: 800-908-4510 EXT. 222

**REEF DISPENSARIES
TENANT IMPROVEMENT**

1930 WEST E AVE BLDG 621
TOOELE, UTAH 84074

REVIEW SET


**SECURITY
FLOOR PLAN**

PROJECT NUMBER 5147	PRINT DATE 6/26/19
DRAWN BY D. PETERSEN	CHECKED BY J. CLEGG
PROJECT MANAGER J. CLEGG	

A1.1



SECURITY FLOOR PLAN
SCALE: 3/32" = 1'-0"

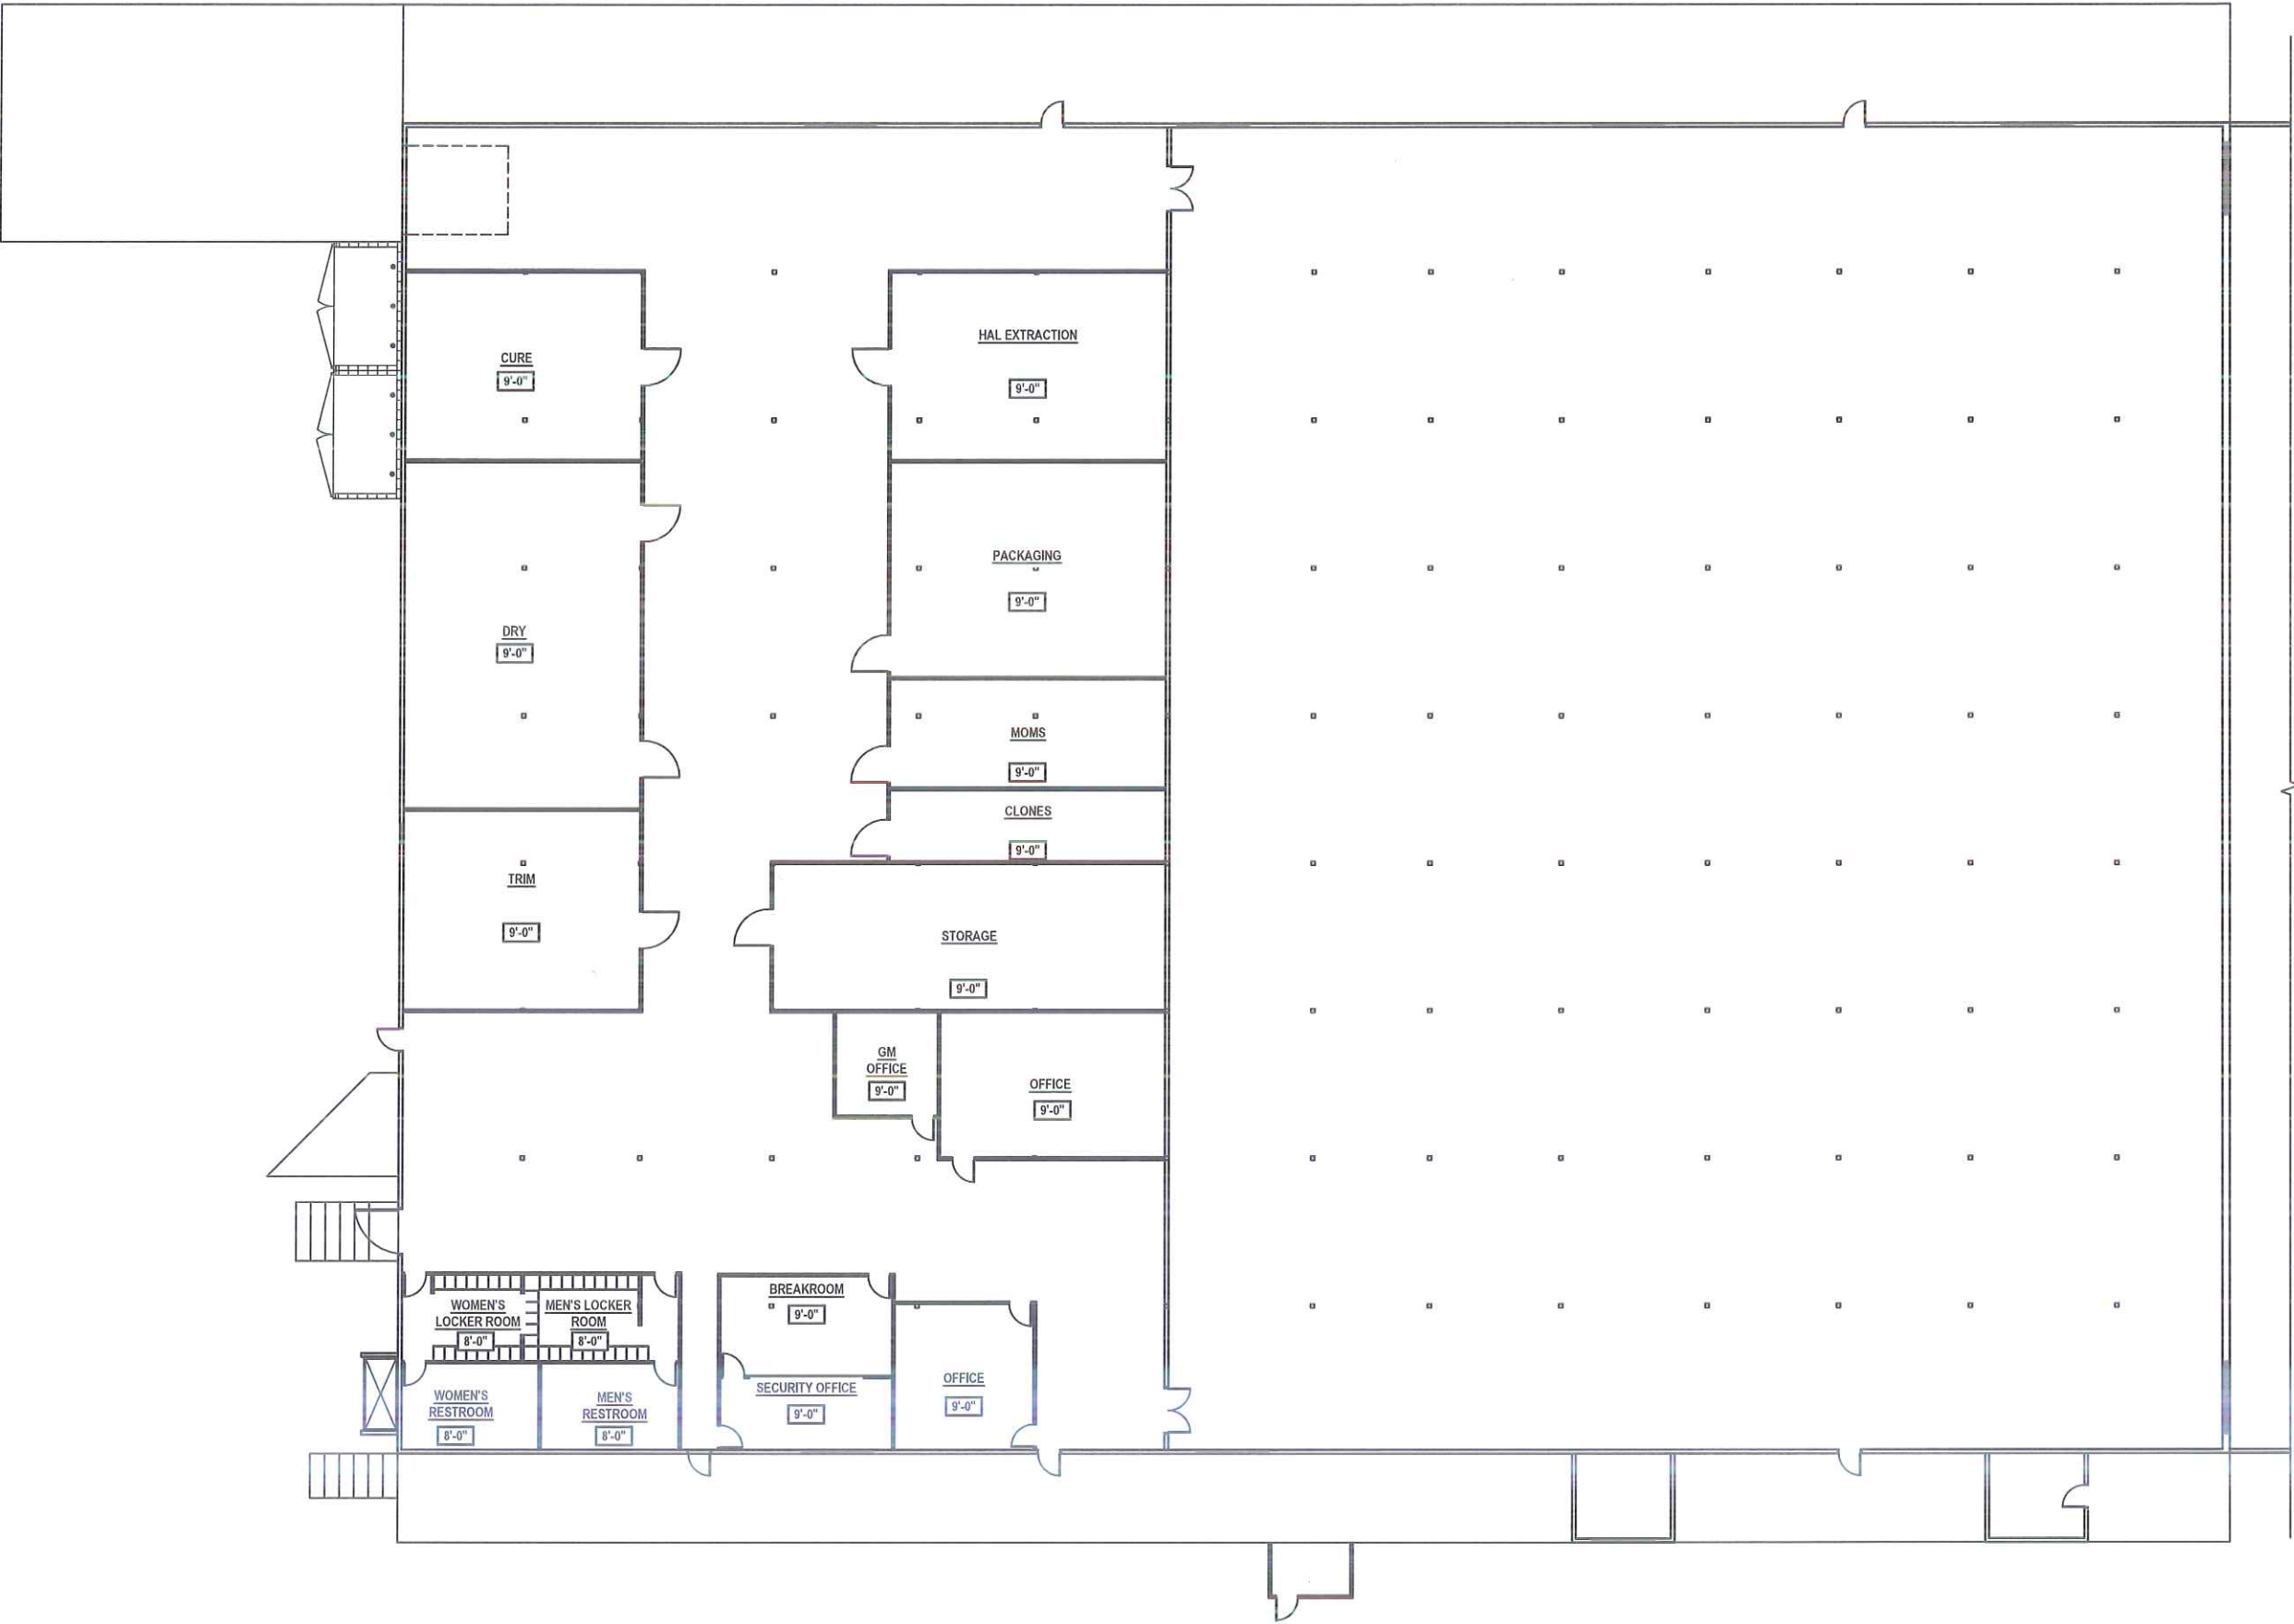

REFLECTIVE CEILING PLAN

SCALE: 3/32" = 1'-0"



TOOELE
169 N. Main Street, Unit 1
Tooele, UT, 84074
Phone: 435.843.3590

SALT LAKE CITY
Phone: 801.255.0529

LAYTON
Phone: 801.547.1100

CEDAR CITY
Phone: 435.865.1453

RICHFIELD
Phone: 435.896.2983

WWW.ENSIGNENG.COM

FOR:
REEF DISPENSARIES
3400 WESTERN AVE
LAS VEGAS, NEVADA 89169

CONTACT:
STEVE VANMEETREN
PHONE: 800-908-6510 EXT. 222




REEF DISPENSARIES
TENANT IMPROVEMENT
1930 WEST E AVE BLDG 621
TOOELE, UTAH 84074

REVIEW SET

REFLECTIVE
CEILING PLAN

PROJECT NUMBER: 5147
PROJECT DATE: 6/26/19
DRAWN BY: D. PETERSEN
DESIGNED BY: J. CLEGG
PROJECT MANAGER: J. CLEGG

A2.0

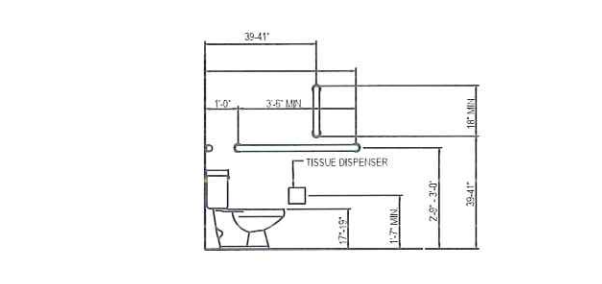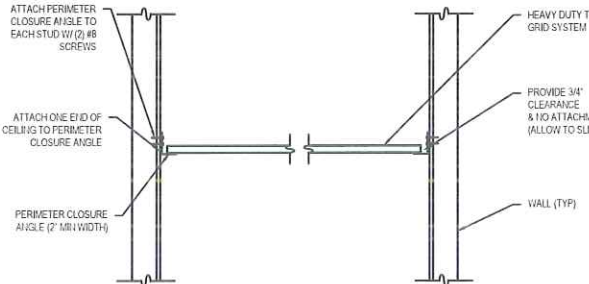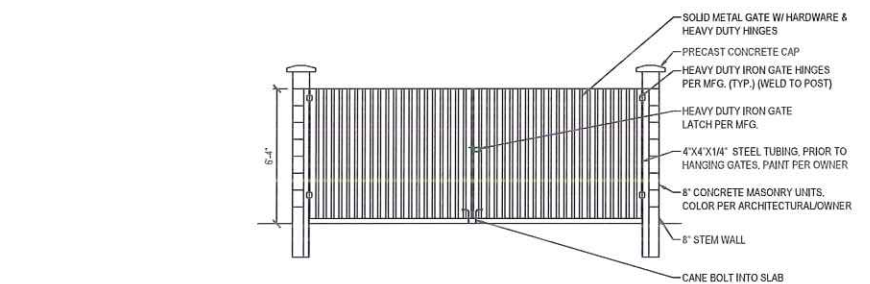



FOR:
REEF DISPENSARIES
3400 WESTERN AVE
LAS VEGAS, NEVADA 89109

CONTACT:
STEVE VANMEETREN
PHONE: 800-908-6510 EXT. 222

**REEF DISPENSARIES
TENANT IMPROVEMENT**
1930 WEST E AVE BLDG 621
TOOELE, UTAH 84074

REVIEW SET

DOCK FOUNDATION
PLAN

PROJECT NUMBER	PRINT DATE
9147	6/26/19
DRAWN BY	CHECKED BY
D. PETERSEN	J. CLEGG
PROJECT MANAGER	
J. CLEGG	

S1.0

ACI 318-14 IBC 2015 / ASCE 7-10

Foundation Schedule			Horizontal Reinforcement		Vertical Reinforcement	
Mark	Wall Height	Thickness	Size	Spacing	Size	Spacing
Typ.	4'	8"	#4	18"	#4	24"
Typ.	8'	8"	#4	18"	#4	24"
Typ.	9'	8"	#4	18"	#4	16"
Typ.	10'	8"	#4	16"	#5	12"

Notes: Wall height refers to final grade difference through the wall. Total height of wall may be higher due to footing drop for frost protection or native soil bearing as long as wall height is backfilled such that the grade difference does not exceed the wall height at any time during construction.

ALL REBAR TO BE GRADE 60.

Place vertical bars in the center of wall.

Extend vertical bars from the footing to within 3" of the top of wall.

Provide dowel with standard hook in the footing to match the vertical rebar.

Extend vertical leg of dowel 24" min. into wall.

Place (1) #4 horizontally within 4" of top and bottom of wall.

Provide concrete reinforcing as to lap 24" min.

Provide (2) #4 above, (1) #4 at each side, and (1) #4 below all openings.

Place steel within 2" of openings & extend 24" min. beyond edge of opening.


Vertical bars around openings may terminate 3" from top of wall.

GENERAL NOTES


1. ALL EXTERIOR FOOTINGS TO BE CONTINUOUS AND POURED MONOLITHIC.
2. FOOTINGS TO BE MINIMUM 10" THICK.
3. ALL FOOTINGS TO BE ON UNDISTURBED NATIVE SOIL.

Footing Schedule						
Mark	Type	Dimensions (Inches)			Reinforcement	
		Thickness	Length	Width	Longitudinal	Transverse
F1.7	Cont.	10	cont.	20	(2) #4	-
F2.0	Cont.	10	cont.	24	(2) #4	-
F2.5	Cont.	10	cont.	30	(3) #4	-
F3.0	Cont.	10	cont.	36	(4) #4	-
SF2.0	Spot	10	24	24	(3) #4	(3) #4
SF2.5	Spot	10	30	30	(3) #4	(3) #4
SF3.0	Spot	10	36	36	(4) #4	(4) #4
SF3.5	Spot	10	42	42	(4) #4	(4) #4
SF4.0	Spot	12	48	48	(5) #4	(5) #4
SF4.5	Spot	12	54	54	(5) #4	(5) #4
SF5.0	Spot	12	60	60	(6) #4	(6) #4
SF5.5	Spot	12	66	66	(6) #4	(6) #4

Notes: Use grade 60 rebar.
All footings must be placed below frost depth unless otherwise noted on plans.

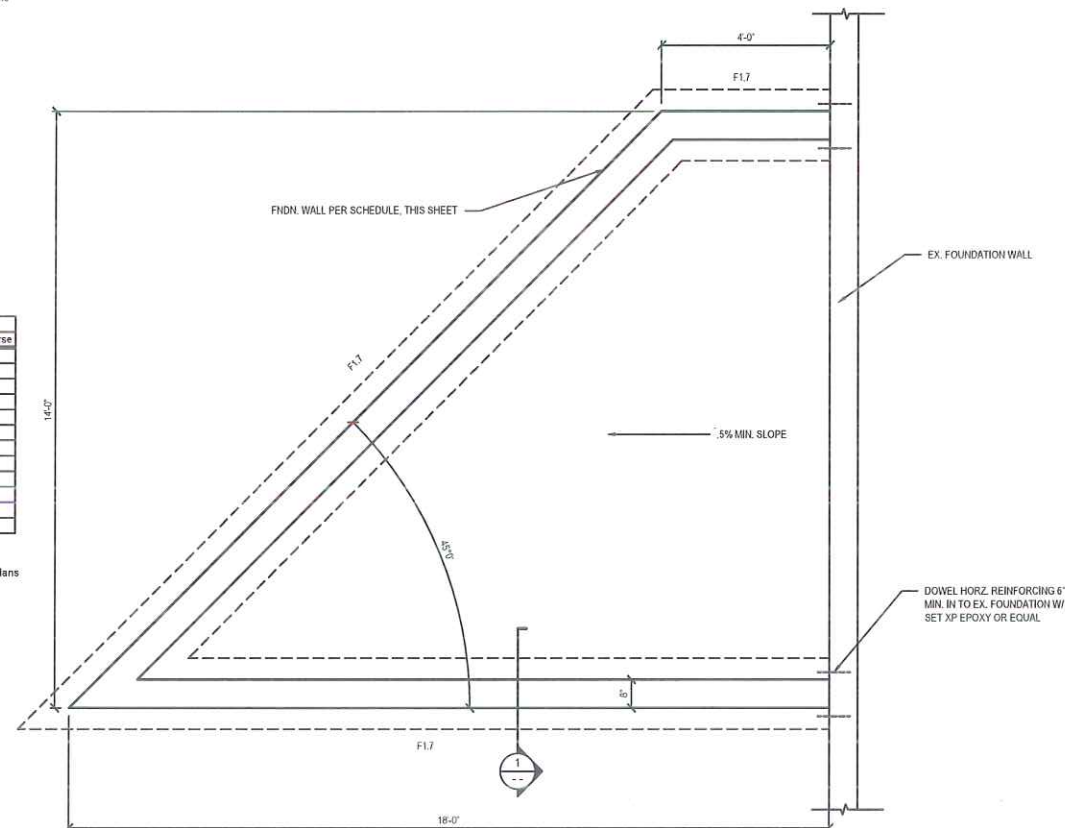

SCALE: 1/2" = 1'-0"

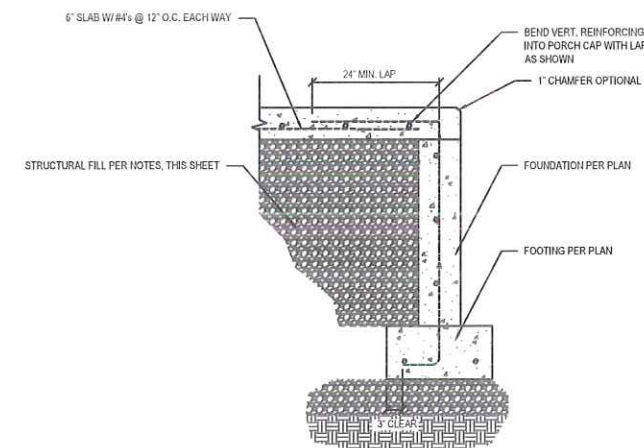

1 DOCK FOUNDATION SECTION

SCALE: NONE