


**NOTE TO GC:**  
PAINT CEILING [P5]  
CONFIRM WITH FIRE MARSHAL PRIOR TO PAINTING MAIN SPRINKLER PIPES [P5] EXCEPT CONNECTIONS. CONNECTIONS TO REMAIN RED IF APPLICABLE.  
DO NOT PAINT UNISTRUT GRID, THREADED ROD DROPS AND DUCTWORK. EXPOSED DUCTWORK IN SALES AREAS AND FIT STUDIO TO REMAIN UNPAINTED EXPOSED GALVANIZED METAL.

**NOTE TO GC:**  
PROVIDE NON COMBUSTIBLE MATERIAL EXPOSED WITHIN PLENUM CEILING OR FIRE RATED BLOCKING AND PLYWOOD WITH FLAME SPREAD INDEX OF NOT MORE THAN 25 AND SMOKE-DEVELOPED INDEX OF NOT MORE THAN 50 WHEN TESTED IN ACCORDANCE WITH ASTM E-84 OR UL 723(RED).

**NOTE:**  
COMBUSTIBLE MATERIAL SHALL NOT BE ALLOWED ABOVE FINISHED CEILINGS

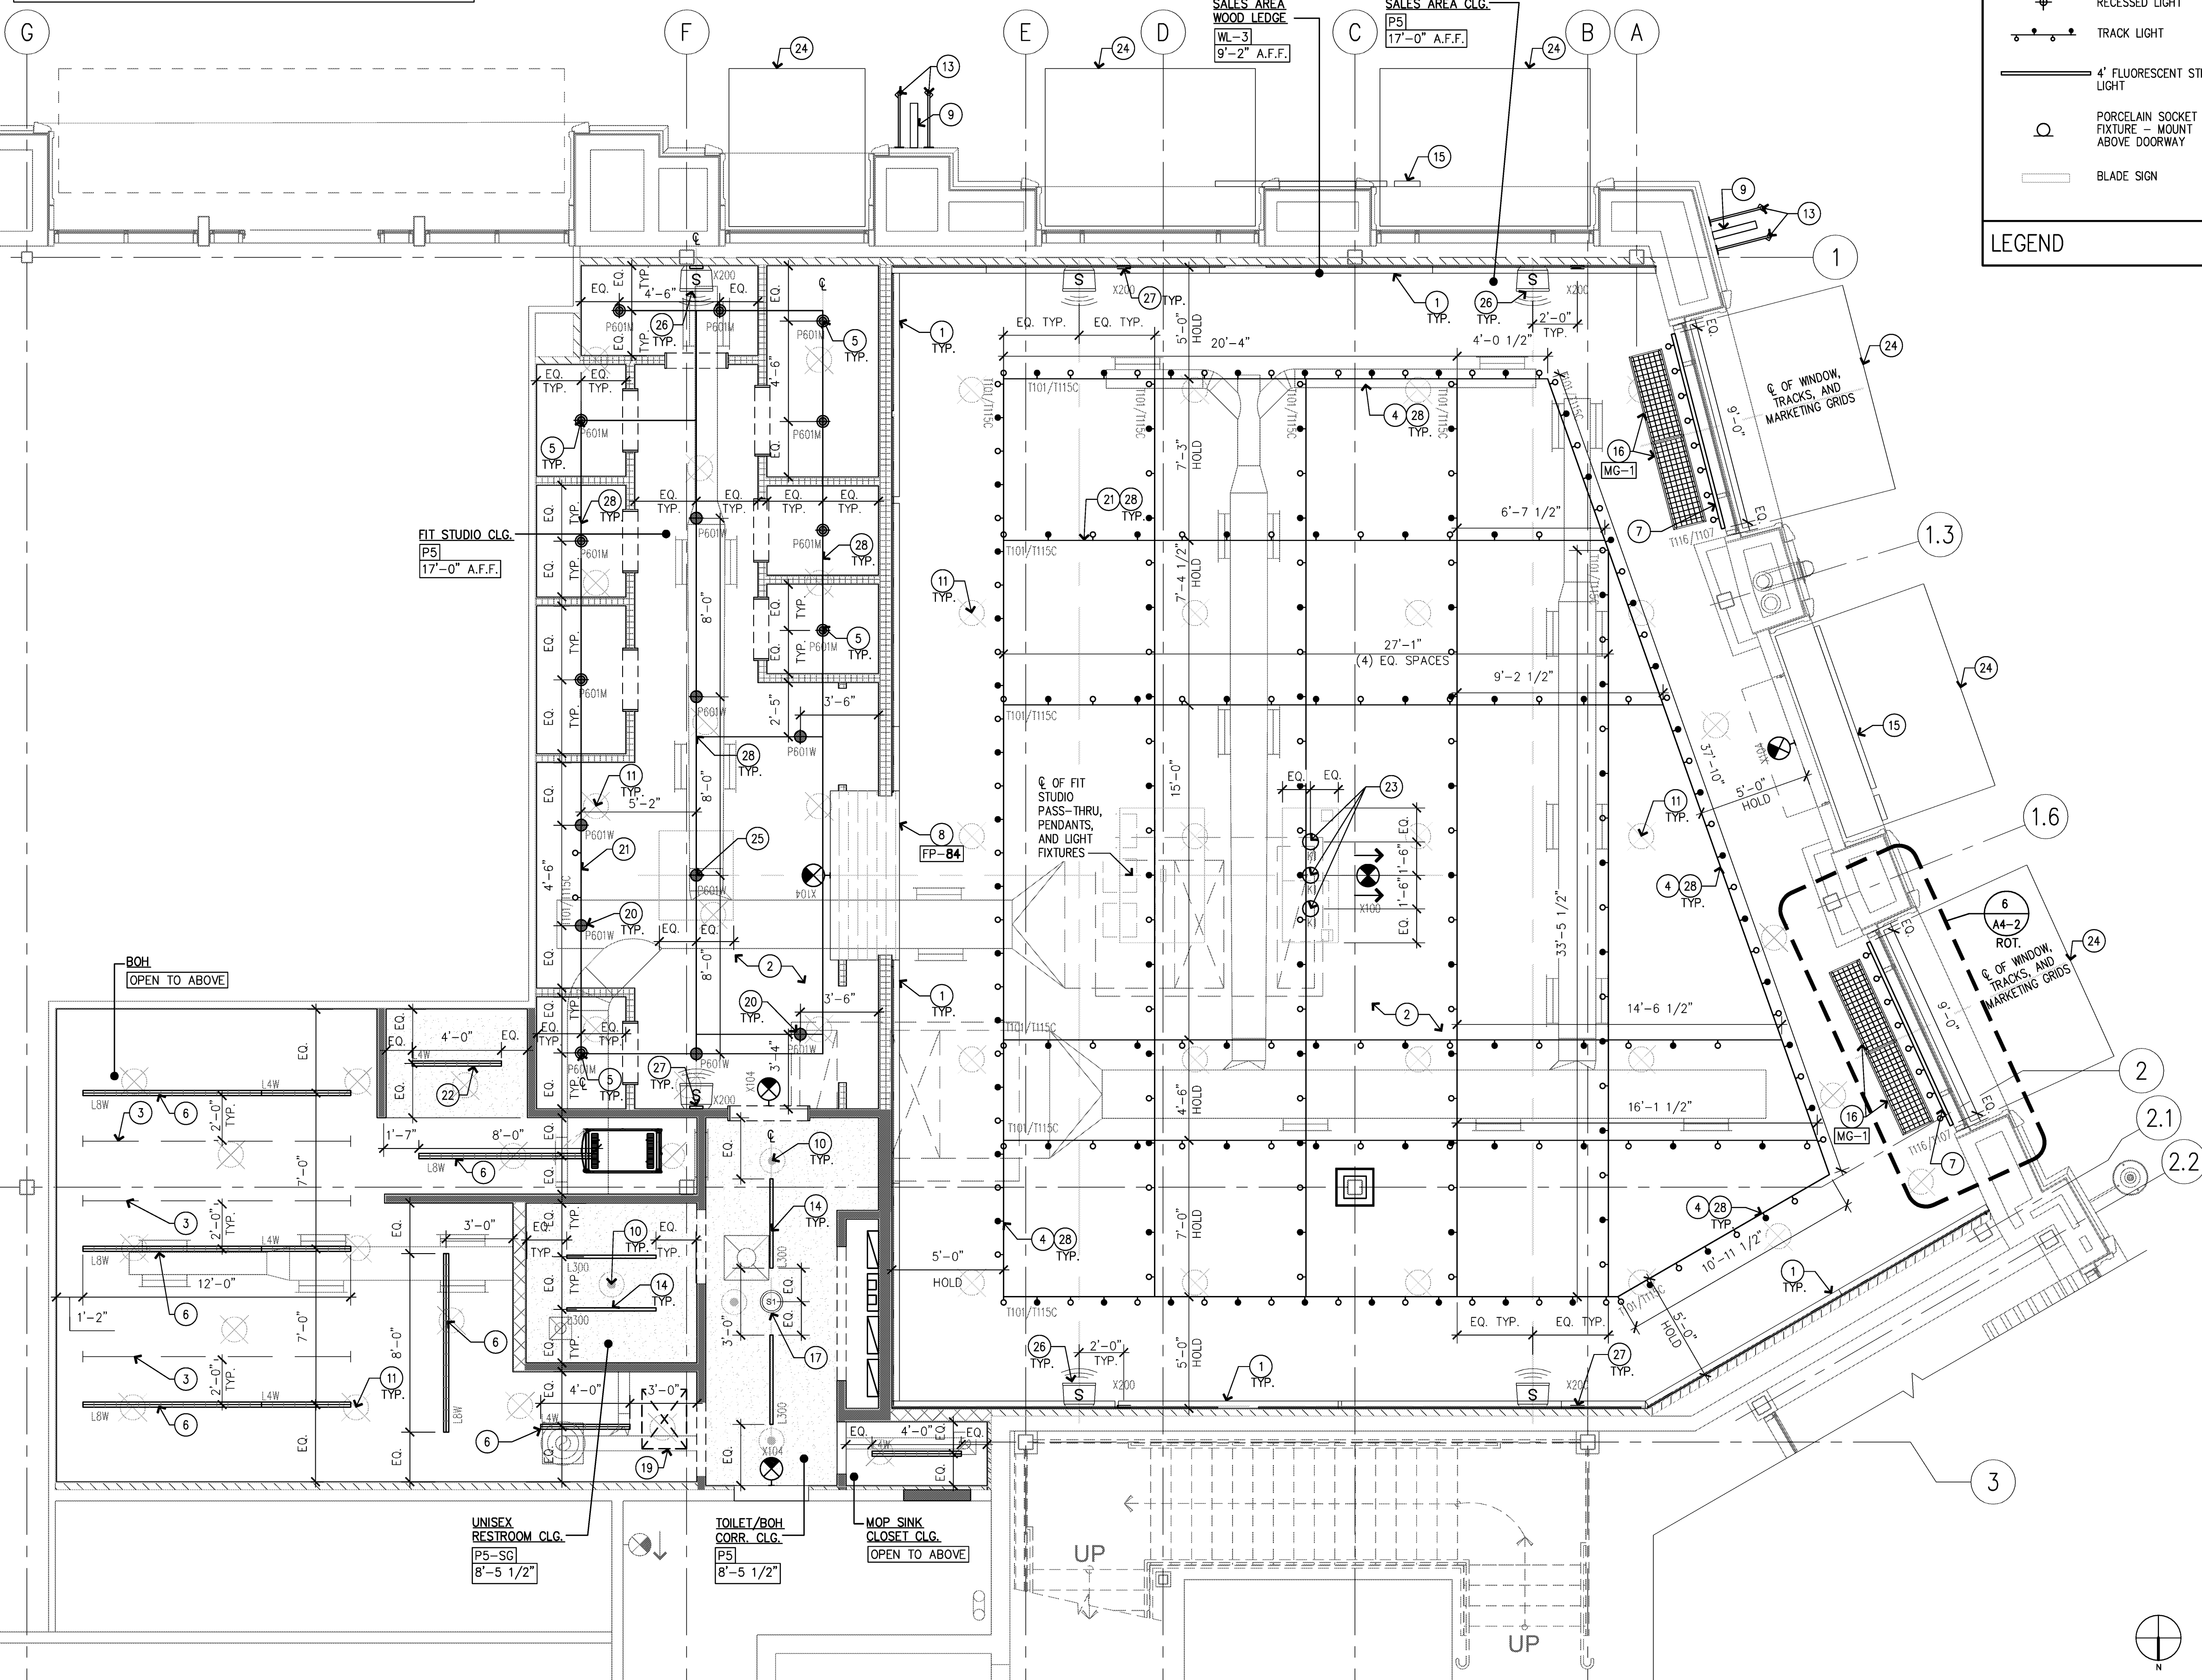

LEGEND	
	4' OR 8' LENSED FLUORESCENT UTILITY LIGHT
	FIT STUDIO PENDANT LIGHT
	RECESSED LIGHT
	TRACK LIGHT
	4' FLUORESCENT STRIP LIGHT
	PORCELAIN SOCKET FIXTURE - MOUNT ABOVE DOORWAY
	BLADE SIGN
	UNISTRUT
	MARKETING GRID
	EMERGENCY LIGHTING UNIT
	ILLUMINATED EXIT SIGN
	RECESSED CEILING SPEAKER
	SURFACE MOUNTED SPEAKER
	CEILING SUPPLY AIR REGISTER
	CEILING RETURN AIR REGISTER
	AIR CURTAIN
	TOILET EXHAUST FAN
	ACCESS PANEL
	CONCEALED FIRE SPRINKLER HEAD
	UPRIGHT FIRE SPRINKLER HEAD
	TRAFFIC COUNTER

KEY	DESCRIPTION	CODE	REF. SHEET
1	4" DEEP WOOD LEDGE ABOVE	WL-3	
2	GC TO PROVIDE GYP. BD. CEILING HELD TIGHT TO B.O. JOISTS TO COVER EXISTING SPRAY FIREPROOFING THROUGHOUT ENTIRE SPACE THAT IS VISIBLE TO CUSTOMERS		
3	CEILING MOUNTED UNISTRUT. MOUNT BOTTOM AT 12'-0" A.F.F.		SEE ELEC.
4	SILVER PERIMETER TRACK LIGHT AND HEADS ( HEAD SPACING AT 18" O.C.) MOUNT TIGHT TO UNPAINTED UNISTRUT GRID	T101/T115C	
5	FITTING ROOM PENDANTS. MOUNT B.O. PENDANTS AT 10'-0" A.F.F. TO UNPAINTED UNISTRUT GRID	P601M	
6	SUSPENDED FLUORESCENT UTILITY LIGHTS IN BOH. MOUNT B.O. FIXTURE AT 13'-0" A.F.F. AND ATTACH TO THE LOWEST OBSTACLE	L4W, L8W	
7	WHITE TRACK LIGHT INSTALLED AT SOFFIT	T116/T107	
8	PORTAL CEILING. B.O. CEILING AT 9'-2" A.F.F.	FP-84	
9	VERTICAL BANNER - ISSUED UNDER SEPARATE PERMIT	S-2.1	1/A4-0A/ 1/A4-0B
10	CONCEALED SPRINKLER HEAD, COLOR TO MATCH ADJ. CLG SURFACE. REFER TO FIRE PROTECTION SHEET		
11	UPRIGHT SPRINKLER HEAD, REFER TO FIRE PROTECTION SHEET		
12	SILVER INTERIOR TRACK LIGHT AND HEADS ( HEAD SPACING AT 24" O.C.) MOUNT TIGHT TO UNPAINTED UNISTRUT GRID	T101/T115C	
13	EXTERIOR LIGHTING RE: ELEC.		
14	SURFACE MOUNTED FLUORESCENT LIGHT	L300	
15	INTERNALLY ILLUMINATED STOREFRONT SIGN - ISSUED UNDER SEPARATE PERMIT	1/A4-0A/ 1/A4-0B	
16	MARKETING GRID AT STOREFRONT WINDOW MOUNT B.O. GRID 12" ABOVE T.O. STOREFRONT OPENING	MG-1	
17	RECESSED SPEAKER, GC TO COORDINATE FINAL LOCATION WITH VENDOR		
18	GC TO PROVIDE ACCESS PANELS FOR FIRE ALARM SAFETY DEVICES. RE: SIZE AND QUANTITY		
19	SUSPENDED ELECTRIC TRANSFORMER		SEE ELEC.
20	FIT STUDIO CORRIDOR PENDANTS. MOUNT B.O. PENDANTS AT 10'-0" A.F.F. TO UNPAINTED UNISTRUT GRID	P601W	
21	SILVER INTERIOR TRACK LIGHT & HEADS ( HEAD SPACING AT 24" O.C.) MOUNT TIGHT TO UNPAINTED UNISTRUT GRID	T101/T115C	
22	FLUORESCENT UTILITY LIGHT - MOUNT TIGHT TO CEILING ABOVE	L4W	
23	PENDANTS CENTERED OVER CASHWRAP. B.O. PENDANTS AT 6'-10" A.F.F.	K-1	
24	(N) AWNING FABRIC AT (E) BRACKETS	S-8.1	
25	PENDANT CENTERED OVER CONCERGE TABLE MOUNT PENDANT TO UNPAINTED UNISTRUT GRID	P601	
26	WHITE SURFACE MOUNTED SPEAKER, GC TO COORDINATE FINAL LOCATION WITH VENDOR. MOUNT 24" ABOVE WOOD LEDGE		
27	RECESSED WALL MOUNTED EMERGENCY LIGHTS AT 14'-0" SEE ELEC.		
28	UNPAINTED GALVANIZED UNISTRUT GRID AND THREADED ROD DROPS, PROVIDED & INSTALLED BY G.C. P1000, MOUNT BOTTOM OF UNISTRUT AT 12'-0" A.F.F. WITH SUPPORTS SPACED AT 8'-0" O.C. MAX.		SEE ELEC.

1. ALL CEILING HEIGHTS INDICATED ON PLANS ARE FROM TOP OF FINISH FLOOR TO UNDERSIDE OF FINISH CEILING U.O.N.  
 2. SEE A6-1 FOR SUSPENDED GYP. BD. CEILING DETAIL.  
 3. PROVIDE ADEQUATE CLEARANCES FOR FIXTURES, DUCTS, CEILINGS AND RELATED PERTINENT ITEMS NECESSARY TO MAINTAIN THE SPECIFIED CEILING HEIGHT ABOVE THE FINISH FLOOR.  
 4. ARCHITECTURAL DRAWINGS DETERMINE THE LOCATION OF LUMINARIES AND SUPERCEDES ALL OTHER DRAWINGS U.O.N.  
 5. SEE ELECTRICAL DRAWINGS FOR FIXTURE MODEL NUMBER.  
 6. ALL LIGHTING FIXTURES PROVIDED BY OWNER AND INSTALLED BY SUBCONTRACTOR U.O.N.  
 7. LATERAL BRACING FOR CEILING MUST BE PROVIDED, WHERE CEILING LOADS ARE LESS THAN 5PSF AND NOT SUPPORTING INTERIOR PARTITIONS, CEILING BRACING SHALL BE PROVIDED BY FOUR NO. 12 GA. WIRES SECURED TO THE MAIN RUNNER WITHIN 2 INCHES OF THE CROSS RUNNER INTERSECTION AND SPAYED 90 DEGREES FROM EACH OTHER AT AN ANGLE LESS THAN OR EQUAL TO 45 DEGREES FROM THE PLANE OF THE CEILING THESE HORIZONTAL RESTRAINT POINTS SHALL BE PLACED 12 FEET O.C. IN BOTH DIRECTIONS WITH THE FIRST POINT WITHIN 4'-0" FROM EACH WALL. ATTACHMENT OF THE RESTRAINT WIRES TO THE STRUCTURE ABOVE SHALL BE ADEQUATE FOR THE LOAD IMPOSED.  
 8. ADDITIONAL HANGARS AND SAFETY WIRES FOR LIGHT FIXTURES, SPEAKERS AND AIR SUPPLY RETURN DIFFUSERS (PER LOCAL CODES) TO BE THE RESPONSIBILITY OF THE CEILING SUB-CONTRACTOR  
 9. PROVIDE ACCESS PANELS AS REQ'D. BY CODE. COORDINATE LOCATIONS WITH ARCHITECT.  
 10. ALL GYP. BD. CEILINGS TO BE SMOOTH FINISH & PAINTED U.O.N.  
 11. ALL MEASUREMENTS ARE TO THE CENTER OF THE FIXTURE U.O.N.  
 12. ALL EXPOSED CONDUITS TO BE MOUNTED TIGHTLY TOGETHER.  
 13. TOUCH UP PAINT OF ALL LIGHT FIXTURES, STEMS, & SCREWS AFTER RETHRADING; PAINT COLOR TO MATCH STEM.  
 14. ALL HATCHED SYMBOLS DENOTE EMERGENCY FIXTURE  
 15. GC TO REFER TO SPECIFICATIONS FOR ADDITIONAL INFORMATION.

**NEW STORE**  
**ATHLETA**  
 GAP INC.  
 STORE DEVELOPMENT  
 2 FOLSOM STREET  
 SAN FRANCISCO, CA 94105

ORACLE I.D.: 140261  
 STORE NUMBER: 7341  
 STORE LOCATION: STATION PARK  
 230 NE PROMONTORY  
 SPACE C-120  
 FARMINGTON, UT 84025

DESIGN TYPE: DERBY B  
 GENERATION: 21034  
 PROTOTYPE DATE: 1/8/2021  
 OPENING: 2021

ARCHITECT INFO:  
**brr**  
 ARCHITECT OF RECORD:  
 MARIAH MEYER  
 8131 METCALF AVE  
 SUITE 300  
 OVERLAND PARK, KS 66204  
 www.brrarch.com  
 TEL: 913-262-9095  
 FAX: 913-262-9044

CONSULTANT INFO:  
 PROFESSIONAL STAMP:

ISSUE TYPE:  
 LL/PERMIT/BID: 02/19/21

REVISIONS:

DRAWN BY: KDA  
 AVE JOB NUMBER: 65011072  
 TITLE SHEET:  
 REFLECTED CEILING PLAN  
 SHEET NUMBER: A3-0A

REFLECTED CEILING PLAN

SCALE: 1/4" = 1'-0"

2

KEYNOTES

1