

by

40. CLEAR FLOOR SPACE - SINK
- ADA (2003) - 60x22
41. TURNING SPACE ADA (2003) - 30x3, 1
42. MANUEVING CLEARANCE - LATCH APPROACH, FULL SIDE W/ CLOSER ADA (2003) - 40x22
43. MANUEVING CLEARANCE - FORWARD APPROACH, PUSH SIDE W/ CLOSER ADA (2003) - 40x22
44. CLEAR FLOOR SPACE ADA (2003) - 30x3
45. CLEAR FLOOR SPACE - WATER CLOSET ADA (2003) - 60x32 EXCEPT 2
47. WATER CLOSET TOLERANCE - ADA (2003) - 60x31
48. 36" WIDE DOOR MINIMUM CLEARANCE PER ADA (2003) - 40x22

THESE DRAWINGS ARE INSTRUMENTS OF SERVICE AND SHALL REMAIN THE PROPERTY OF THE ARCHITECT. NO REUSE OR RE-USE OF THESE DOCUMENTS SHALL BE PERMITTED WITHOUT THE WRITTEN CONSENT OF THE ARCHITECT. NO DESIGN STUDIO, I.L.C. WITH APPROPRIATE COMPENSATION.

NOTES:

1. CONTACT ARCHITECT FOR ANY CLARIFICATION REQUIRED, INCLUDING POSSIBLE DISCREPANCIES ON THE DRAWINGS.
2. FIELD VERIFY ALL EXISTING CONDITIONS PRIOR TO STARTING ANY WORK.
3. GENERAL CONTRACTOR IS RESPONSIBLE FOR FULL COMPLIANCE WITH GOVERNING CODES AND REGULATIONS, COORDINATION OF SUBCONTRACTORS,

1. CONTACT ARCHITECT FOR ANY CLARIFICATION REQUIRED, INCLUDING POSSIBLE DISCREPANCIES ON THE DRAWINGS.
2. FIELD VERIFY ALL EXISTING CONDITIONS PRIOR TO STARTING ANY WORK.
3. GENERAL CONTRACTOR IS RESPONSIBLE FOR FULL COMPLIANCE WITH GOVERNING CODES AND REGULATIONS, COORDINATION OF SUBCONTRACTORS,

A-1.1

PLUMBING FIXTURE & ACCESSORY SCHEDULE

1. CONTRACTOR TO FIELD VERIFY ALL EXISTING CONDITIONS AND DIMENSIONS PRIOR TO STARTING ANY WORK. CONTRACT ARCHITECT FOR ANY CLARIFICATION REQUIRED.


2. CONTRACTOR TO FIELD VERIFY NEW WALL LOCATIONS AND DIMENSIONS AS SHOWN ON DRAWINGS. CONTRACT ARCHITECT FOR ANY CLARIFICATION REQUIRED, INCLUDING POSSIBLE DISCREPANCIES BETWEEN THE DRAWINGS AND ACTUAL EXISTING BUILT CONDITIONS.

DOOR HARDWARE GROUPS


44 NOT TO SCALE

SCALE: 1/2" = 1'-0"


SCALE: 1/2"=1'-0"

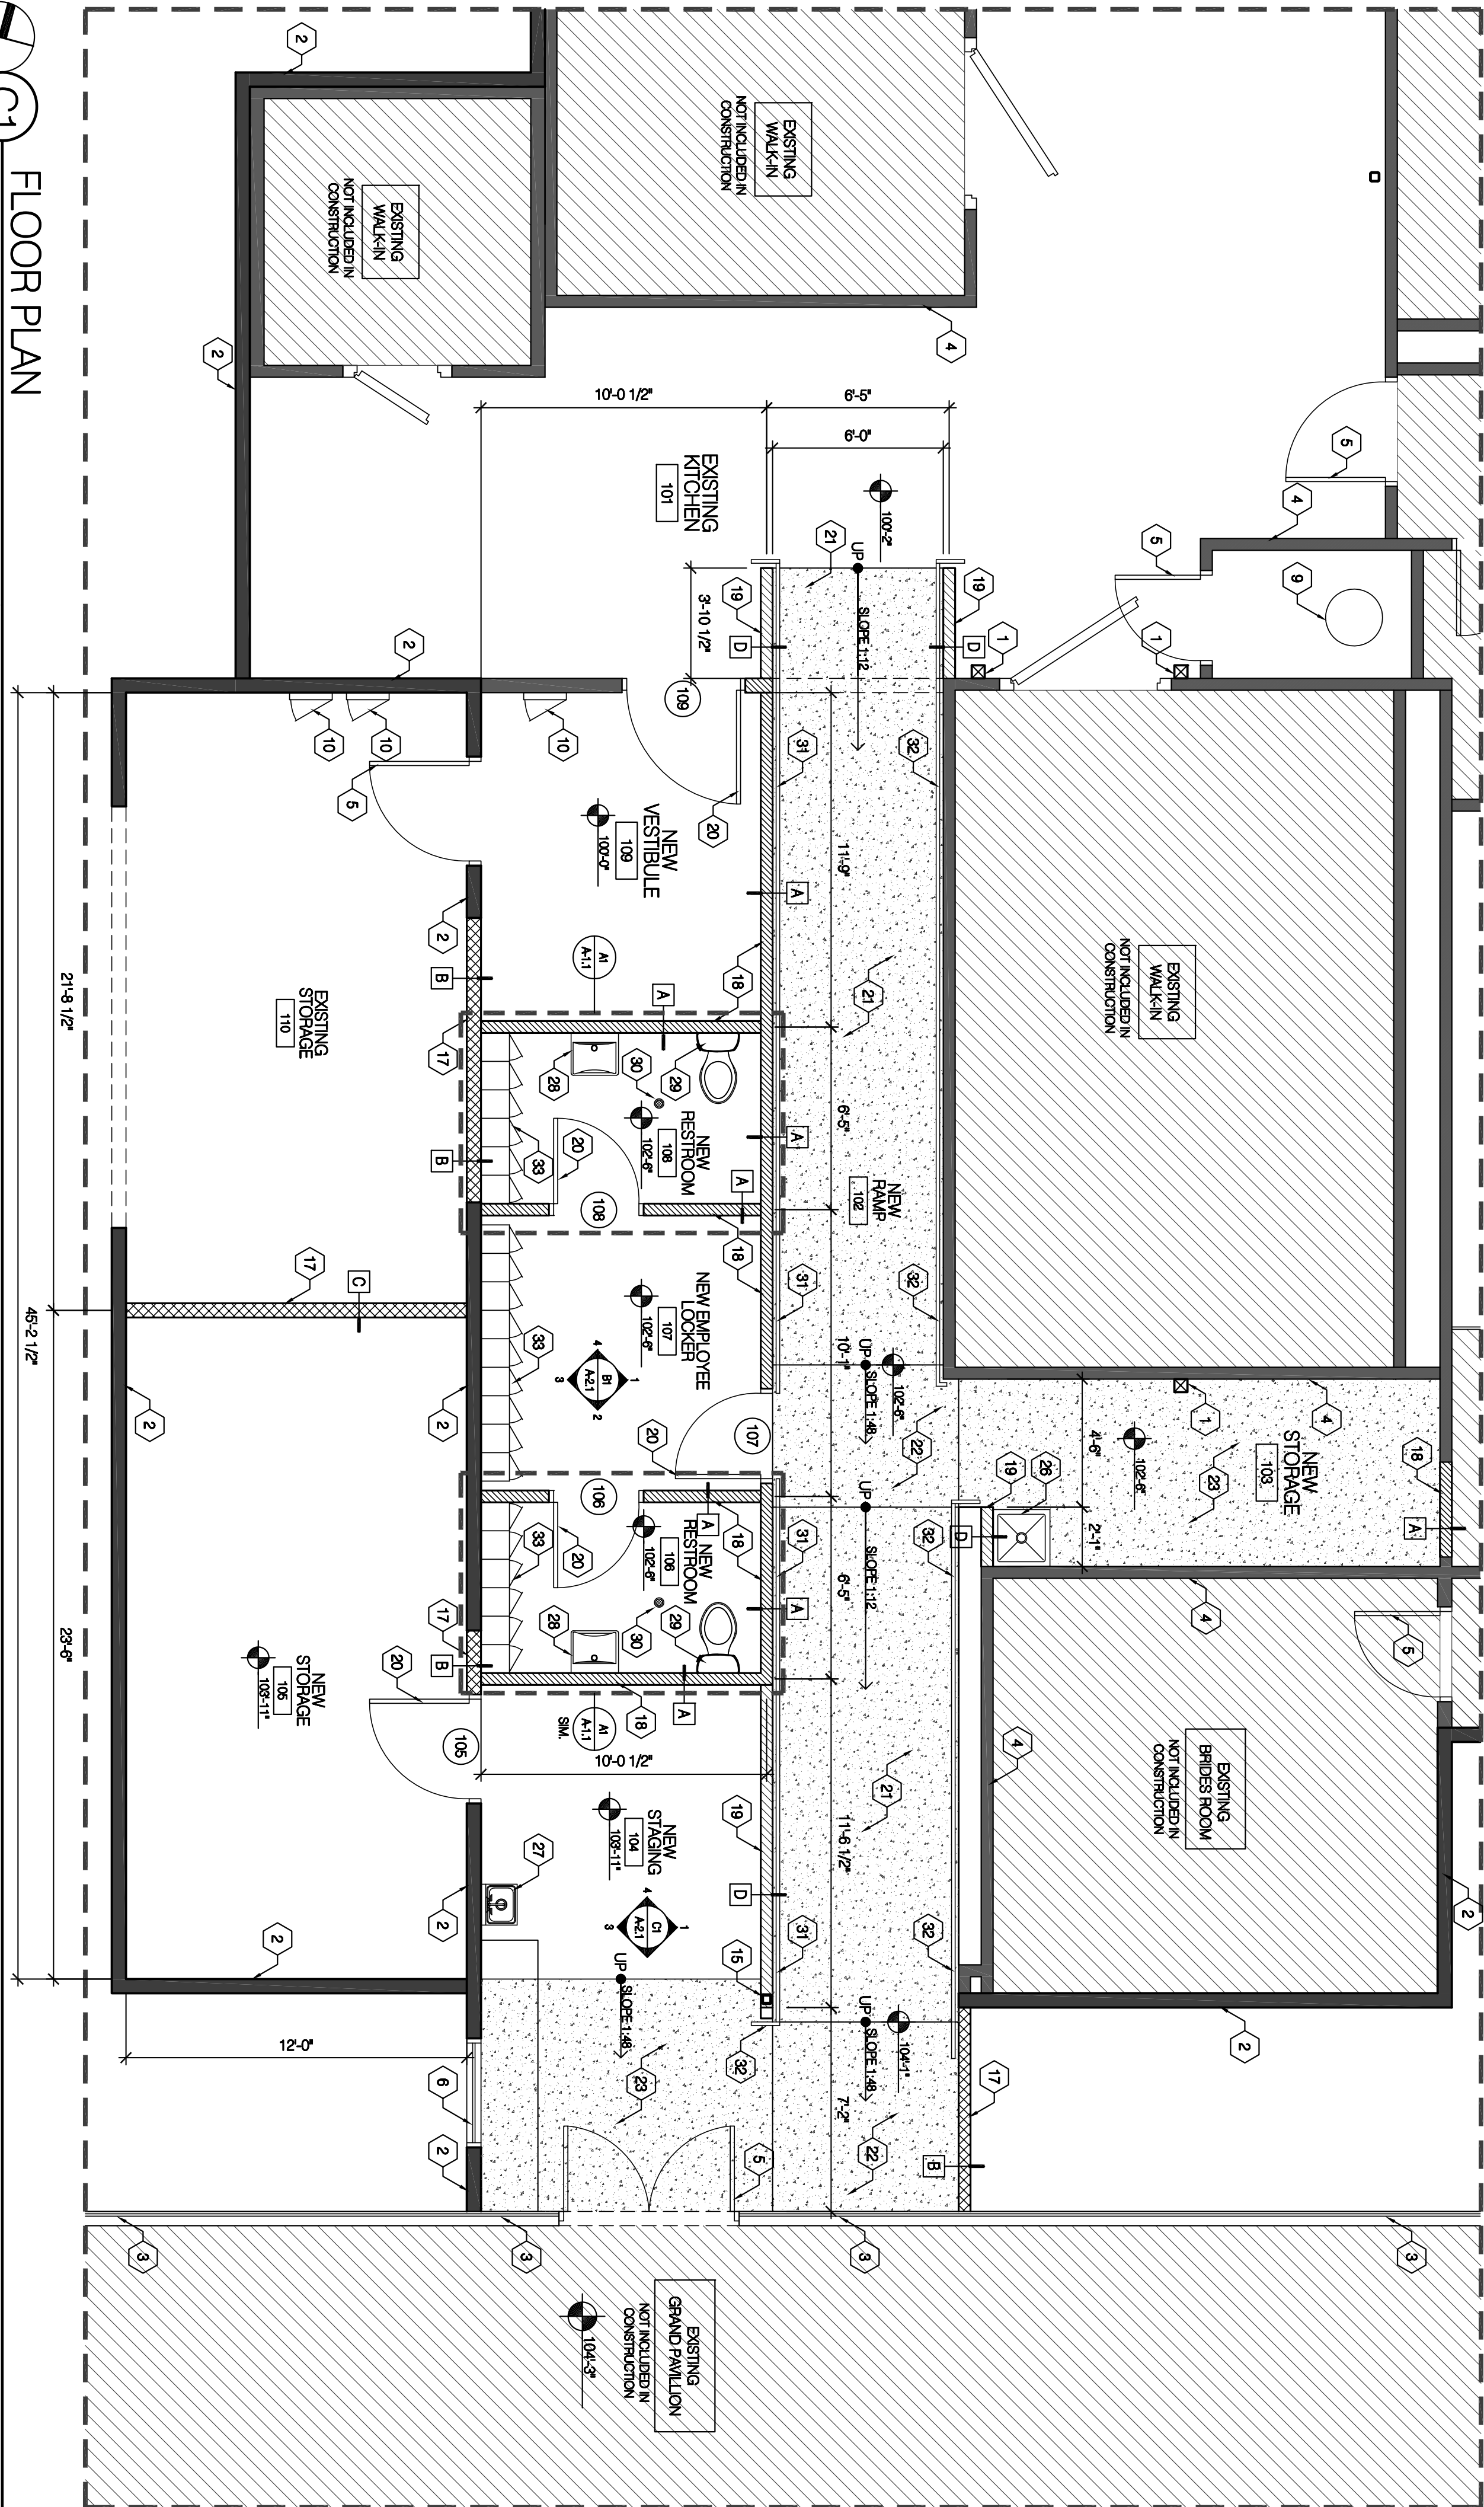

SCALE: 1/4"=1'-0"

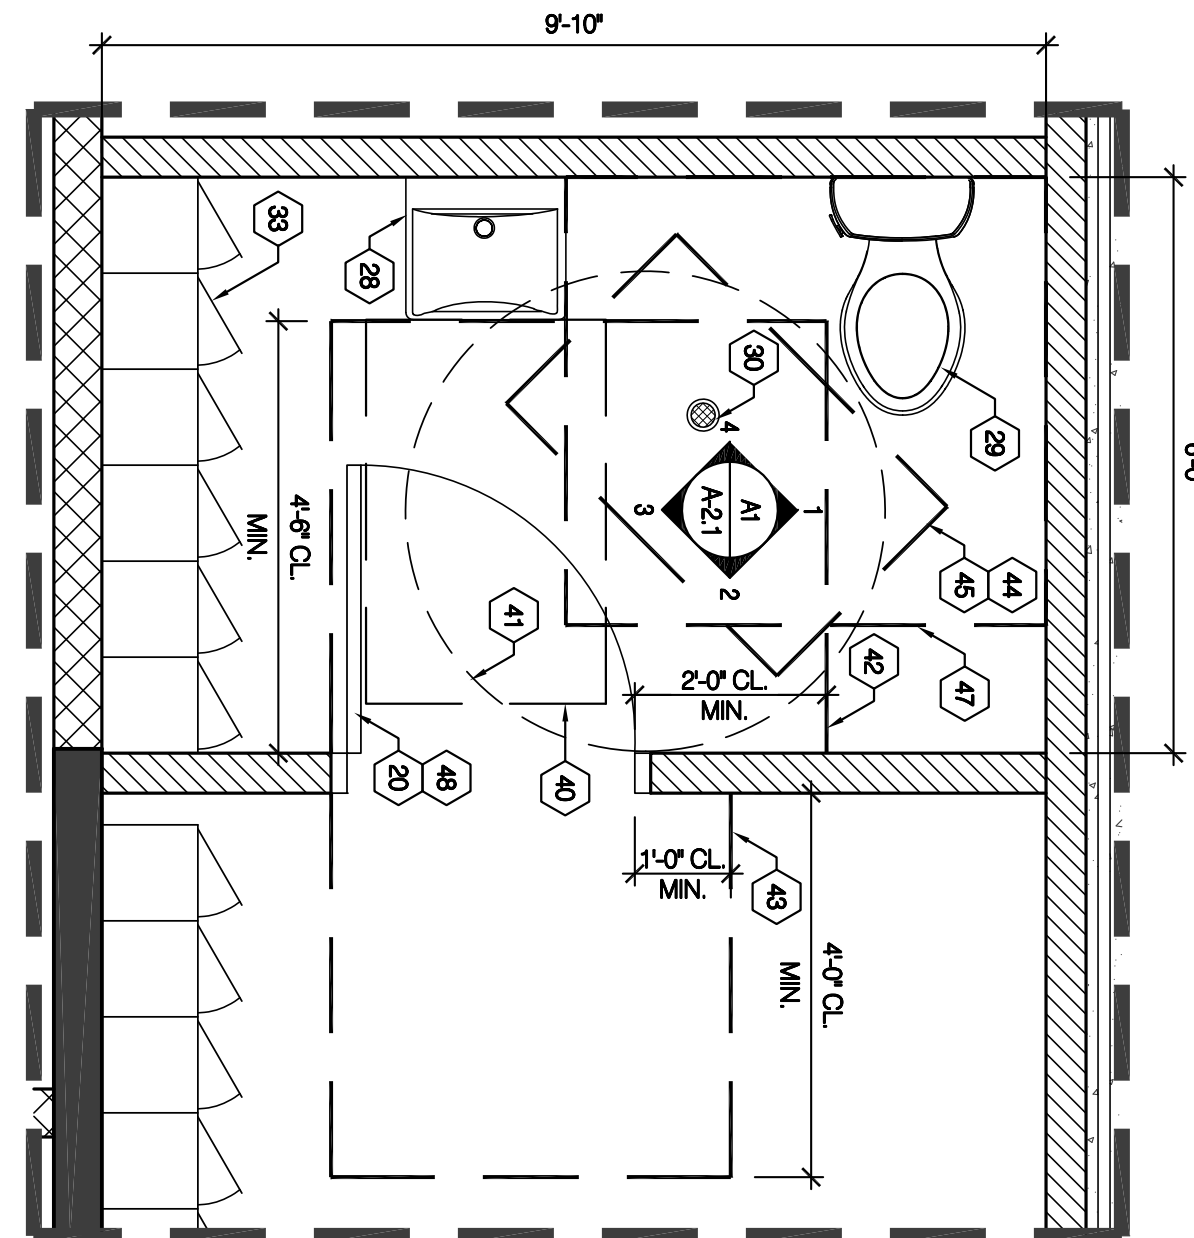

SCALE: 1/2" = 1'-0"

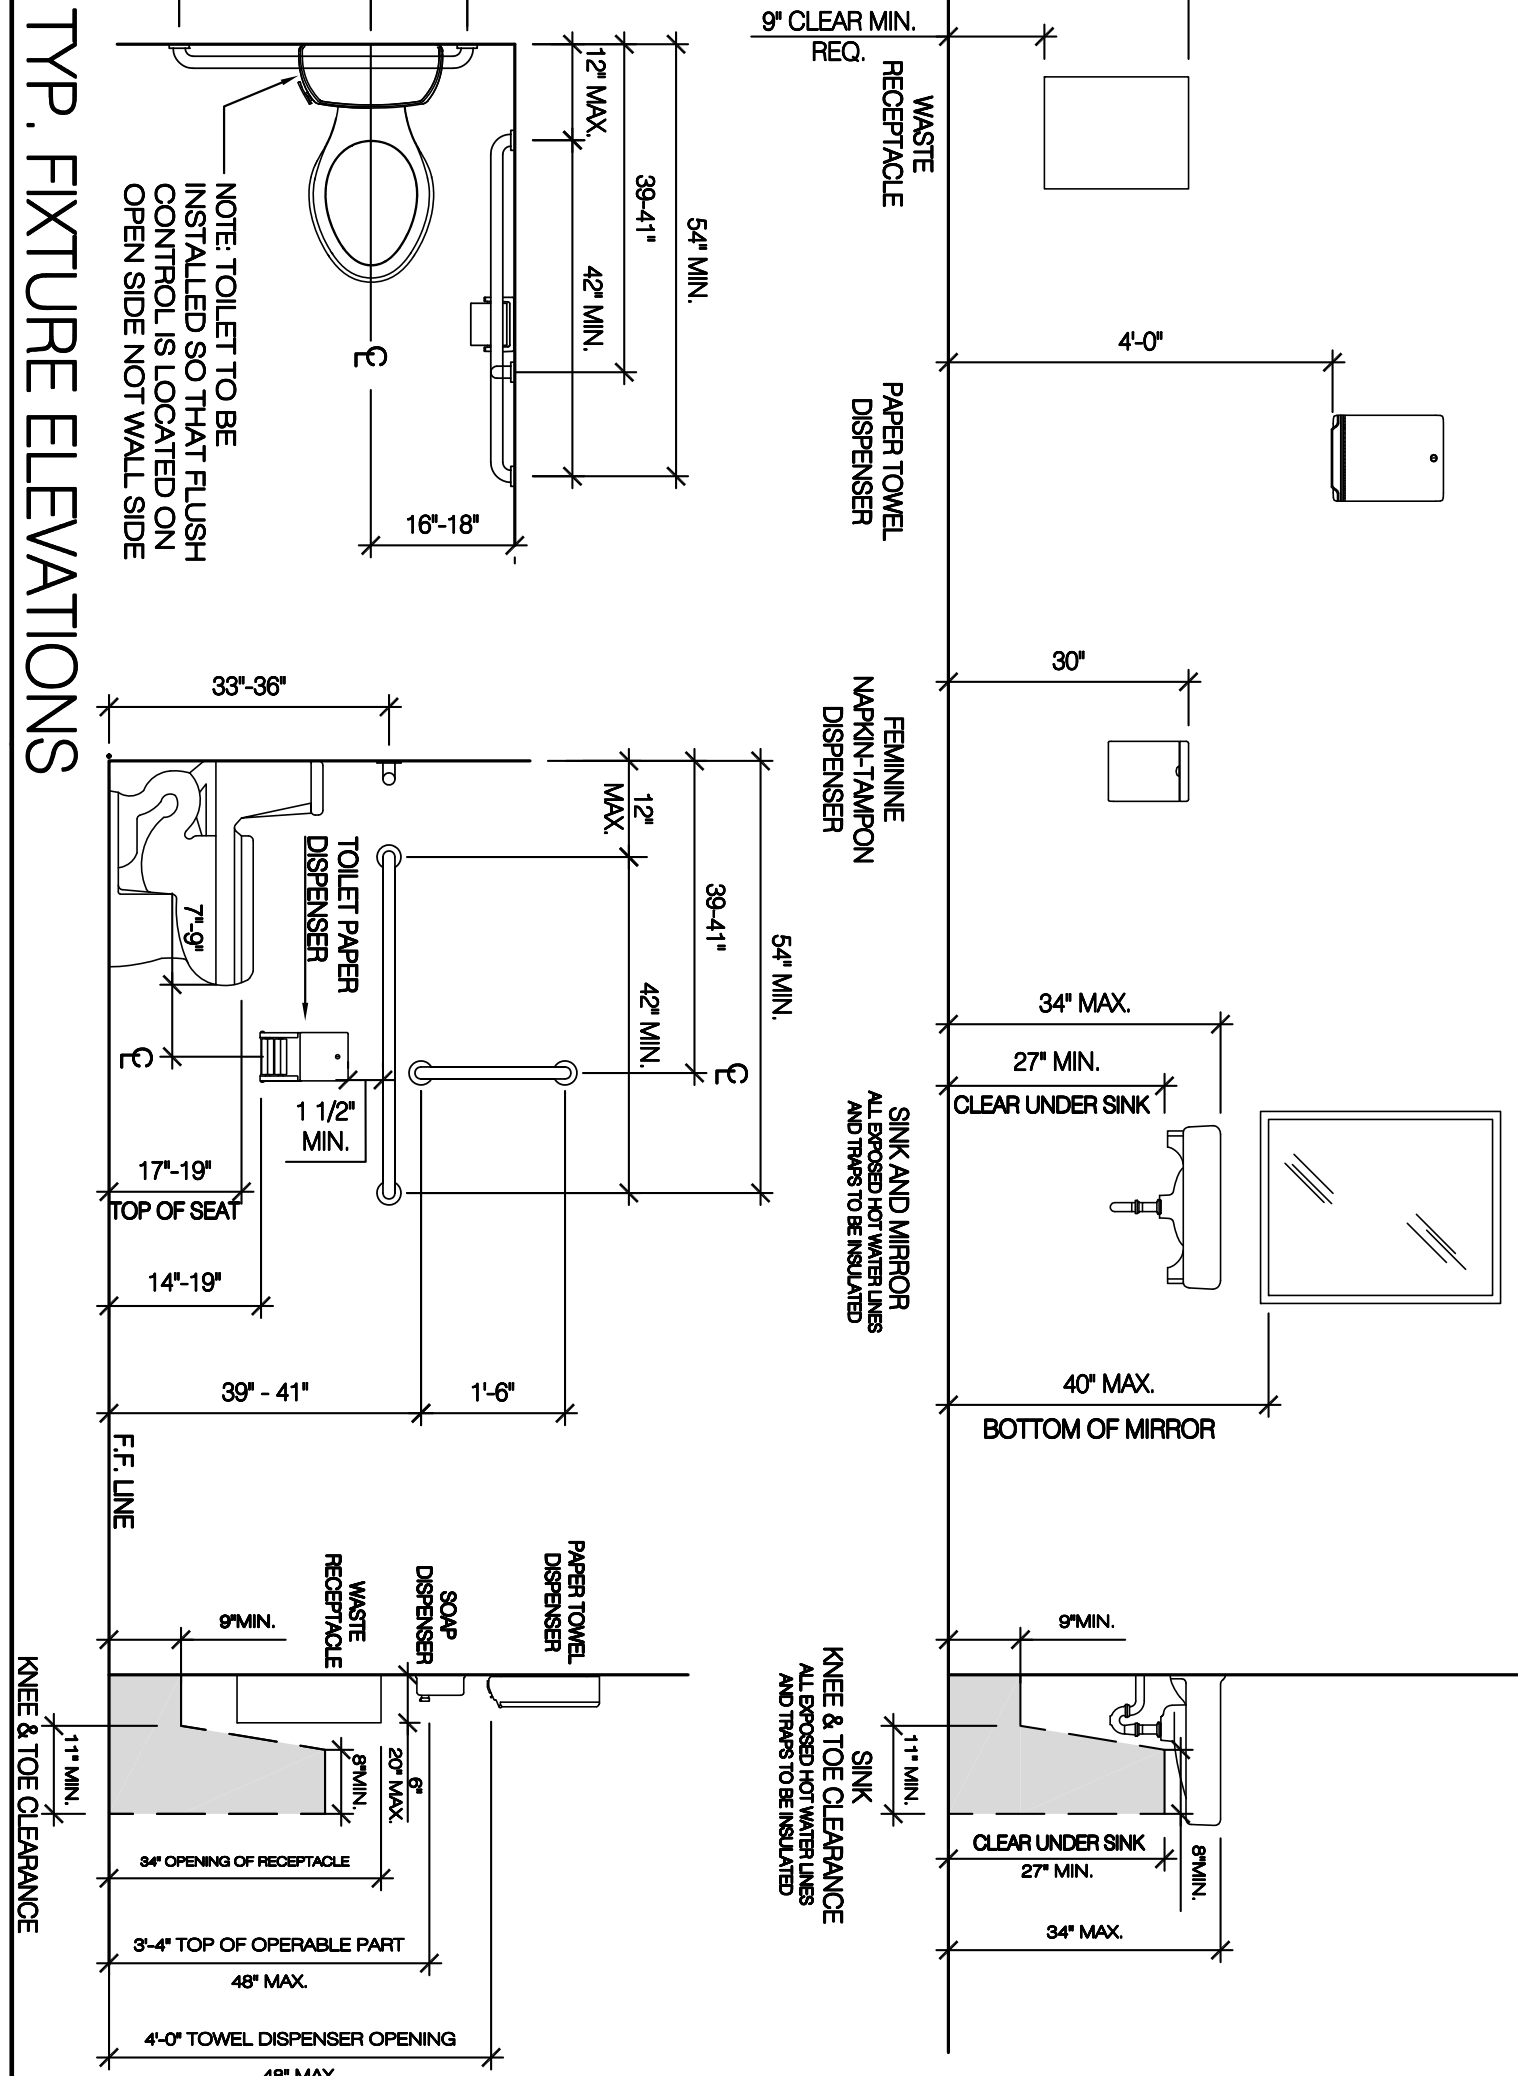

44 NOT TO SCALE