



THIS DRAWING SHEET AND ALL INFORMATION HEREON IS COPYRIGHTED AND THE PROPERTY OF JTB HVAC & PLUMBING ENGINEERING, INC. AND SHALL NOT BE USED ON ANY OTHER PROJECT WITHOUT WRITTEN PERMISSION FROM JTB HVAC & PLUMBING ENGINEERING, INC.

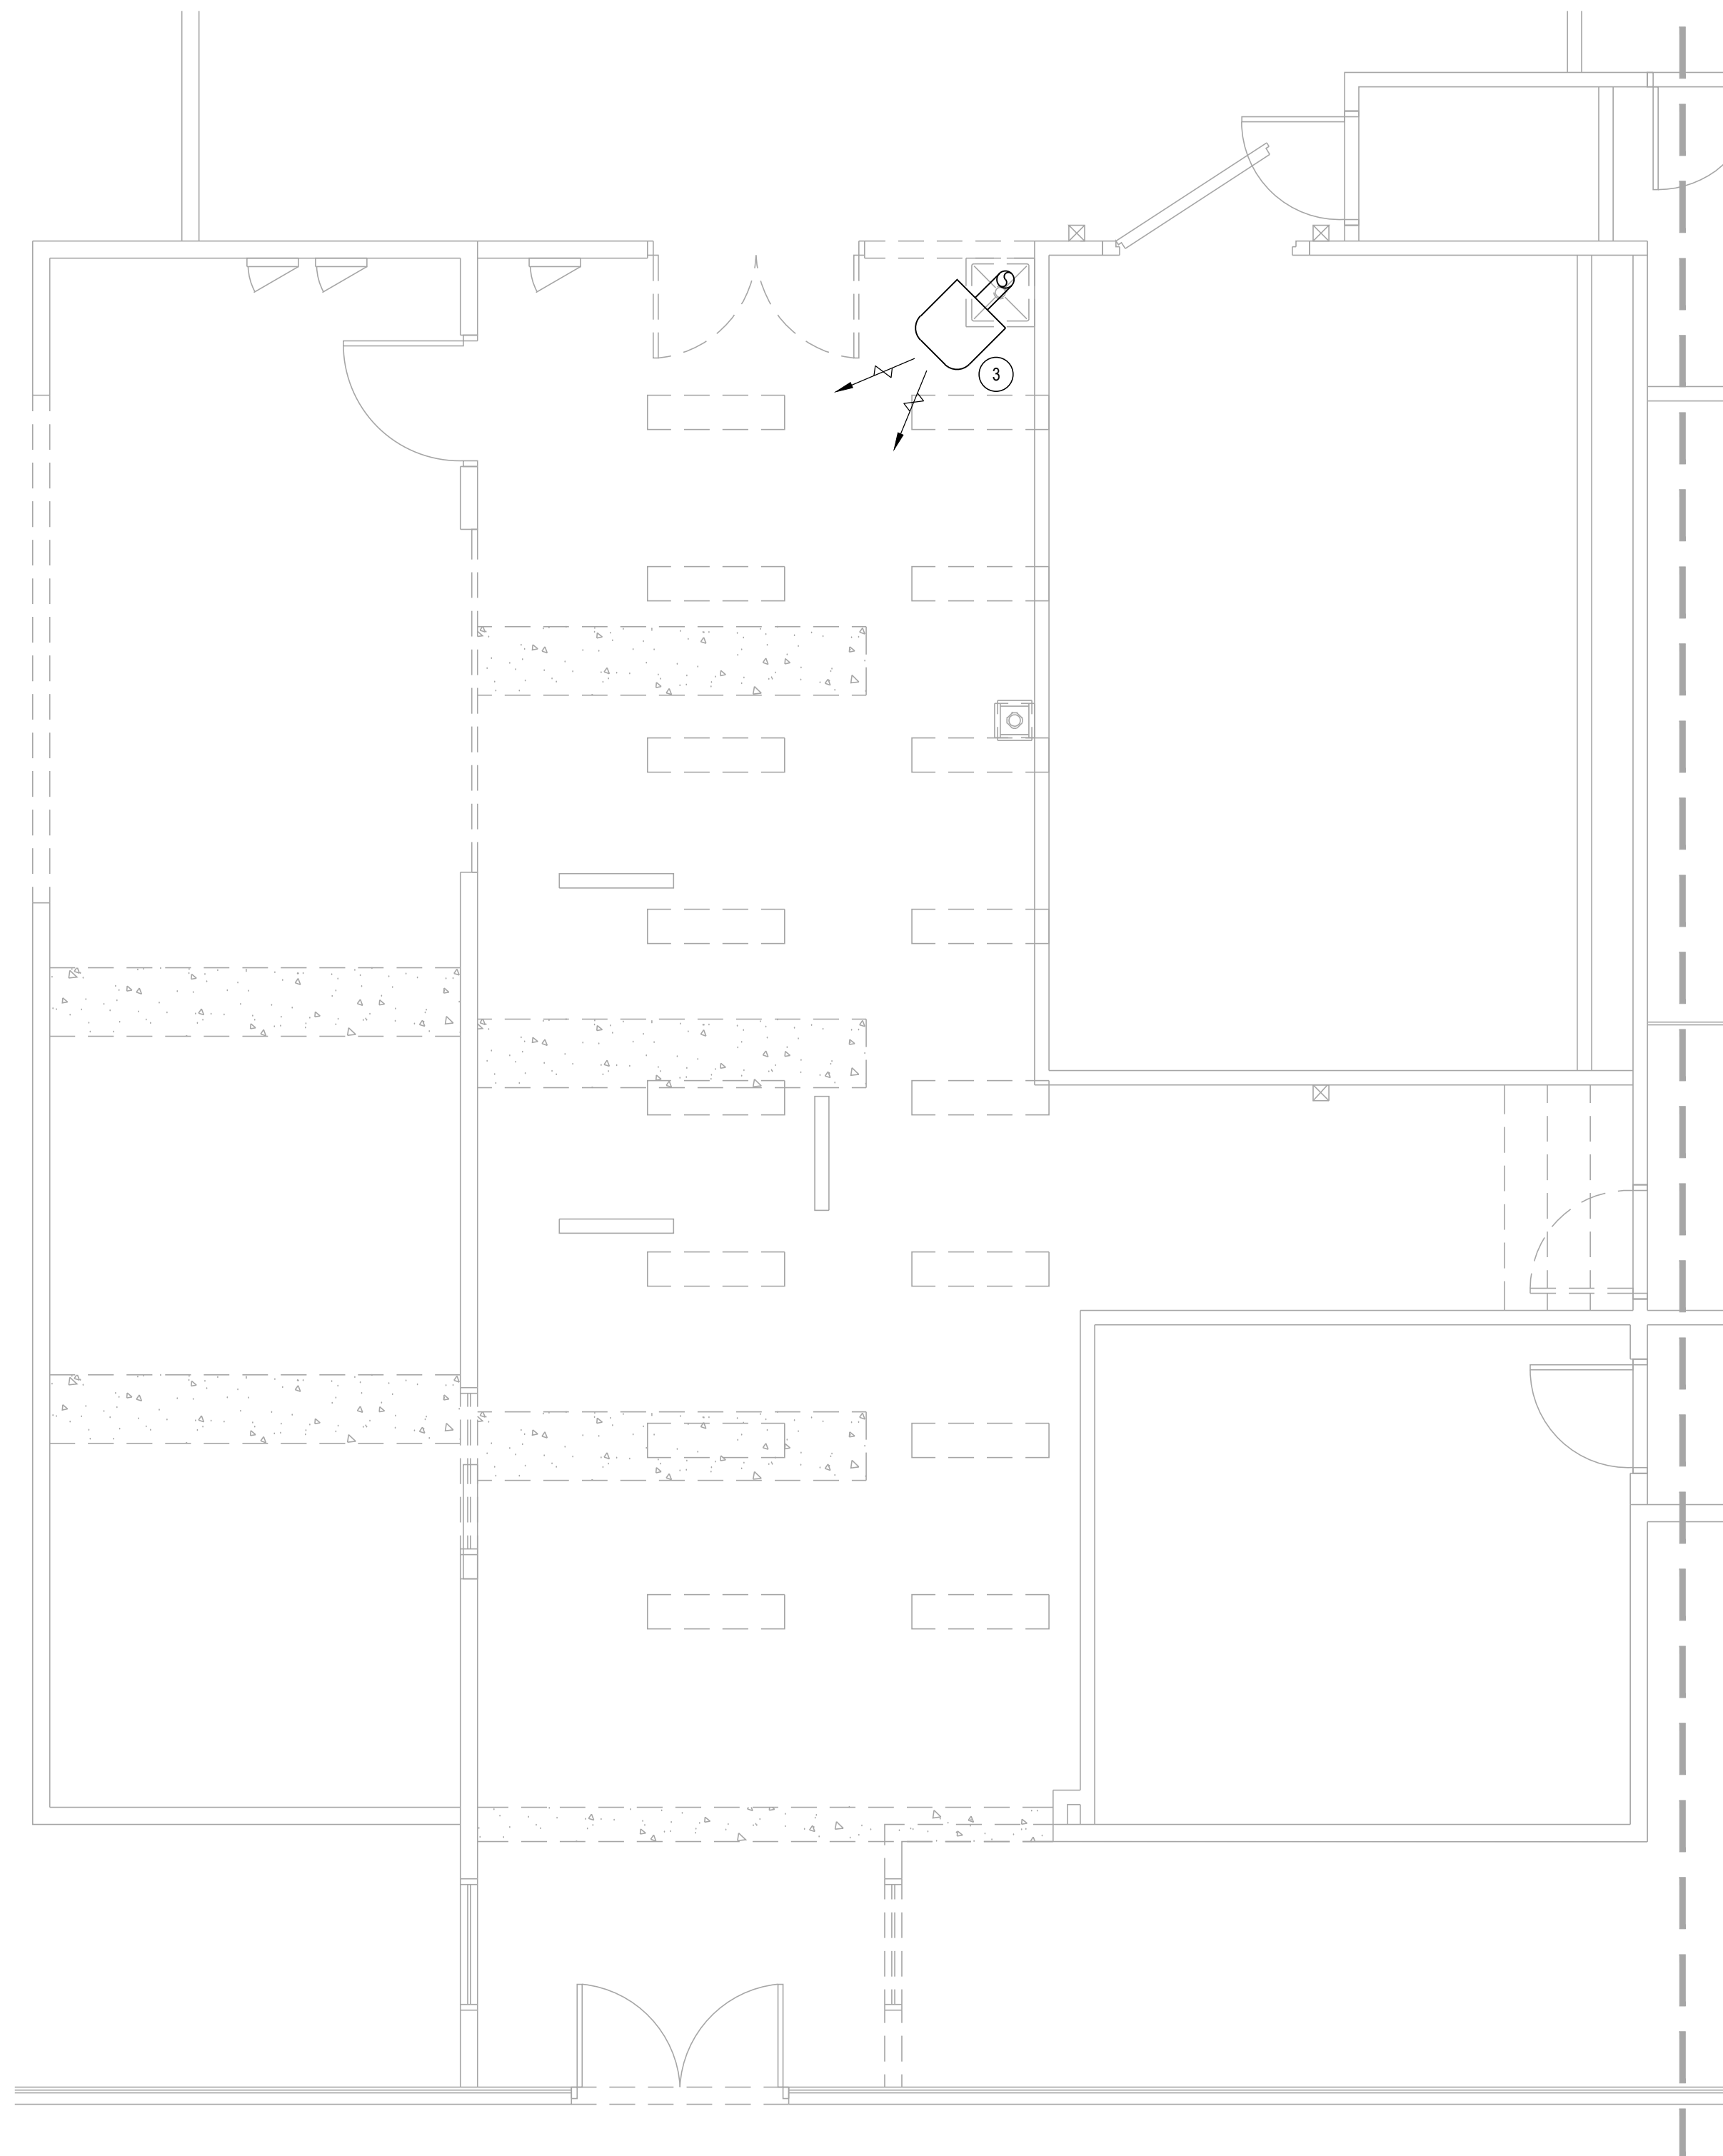


NORTH
MECHANICAL DEMO PLAN
SCALE: 1/4"=1'-0"

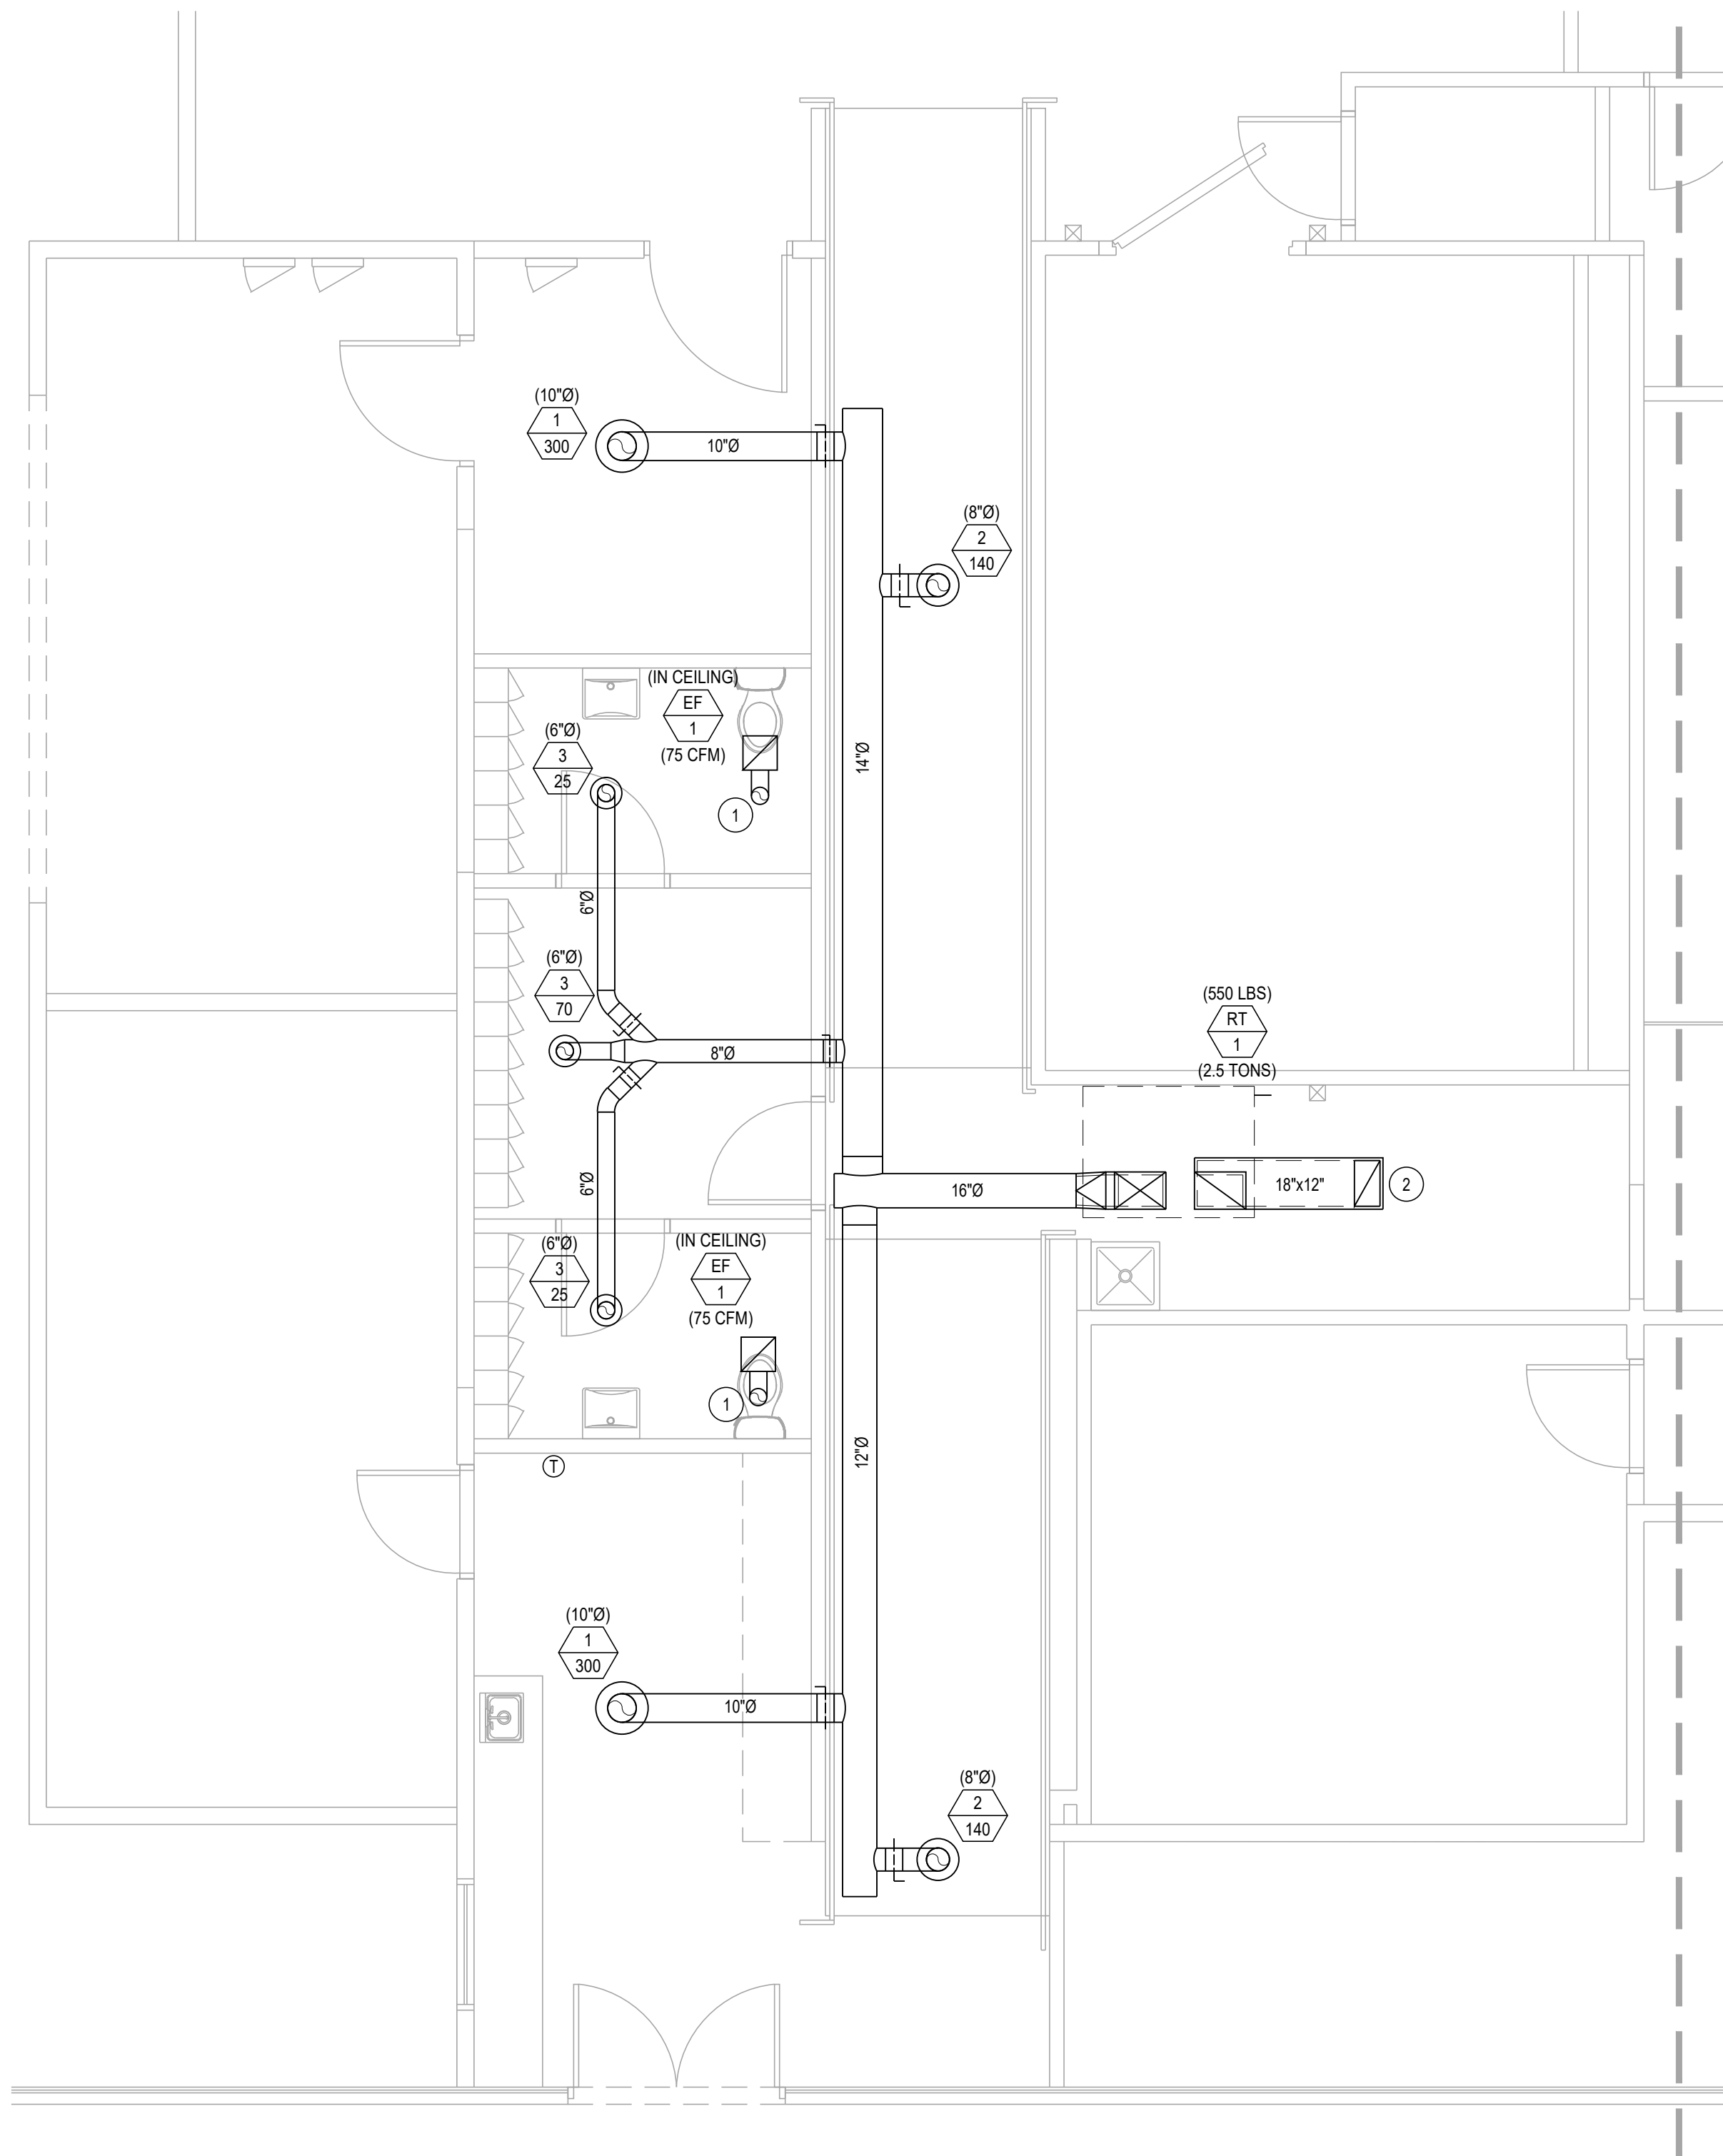

NORTH
MECHANICAL PLAN
SCALE: 1/4"=1'-0"

KEYED NOTES

- 1 6"Ø EXHAUST UP THRU THE ROOF WITH RAIN CAP.
- 2 18"x12" OPENING IN TOP OF DUCT FOR RETURN AIR.
- 3 REMOVE EXISTING UNIT HEATER AND FLUE. PATCH ROOF OPENING BY GC.

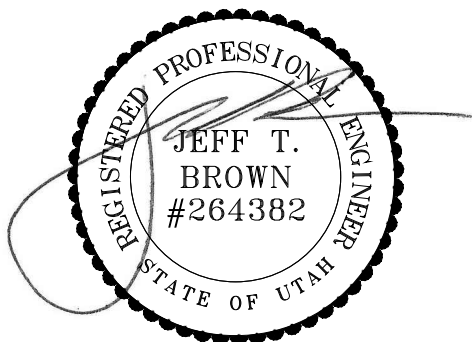

PERMIT SET

REV.	DATE	DESCRIPTION
-	-	-
-	-	-
-	-	-
-	-	-
B	01/23/2018	REVISED PER COMMENTS
A	01/19/2018	RELEASED FOR PERMIT

JTB JTB HVAC & Plumbing
Engineering, Inc.
10459 South 1300 West, Suite 203
South Jordan, Utah 84095
WWW.JTBEngineering.net
PH: (801) 849-8590

PROJECT NAME:
**LA CAILLE- BANQUET
SUPPORT REMODEL**

ADDRESS
9565 WASATCH BLVD
SANDY, UT 84092

DRAWING TITLE:
**MECHANICAL
PLAN**

JOB NO.:	18.005	SHEET NUMBER
DATE:	01/23/2018	M201
DRAWN BY:	JTB	
SCALE:	NTS	