




THIS DRAWING SHEET AND ALL INFORMATION HEREON IS COPYRIGHTED AND THE PROPERTY OF JTB HVAC & PLUMBING ENGINEERING, INC. AND SHALL NOT BE USED ON ANY OTHER PROJECT WITHOUT WRITTEN PERMISSION FROM JTB HVAC & PLUMBING ENGINEERING, INC.

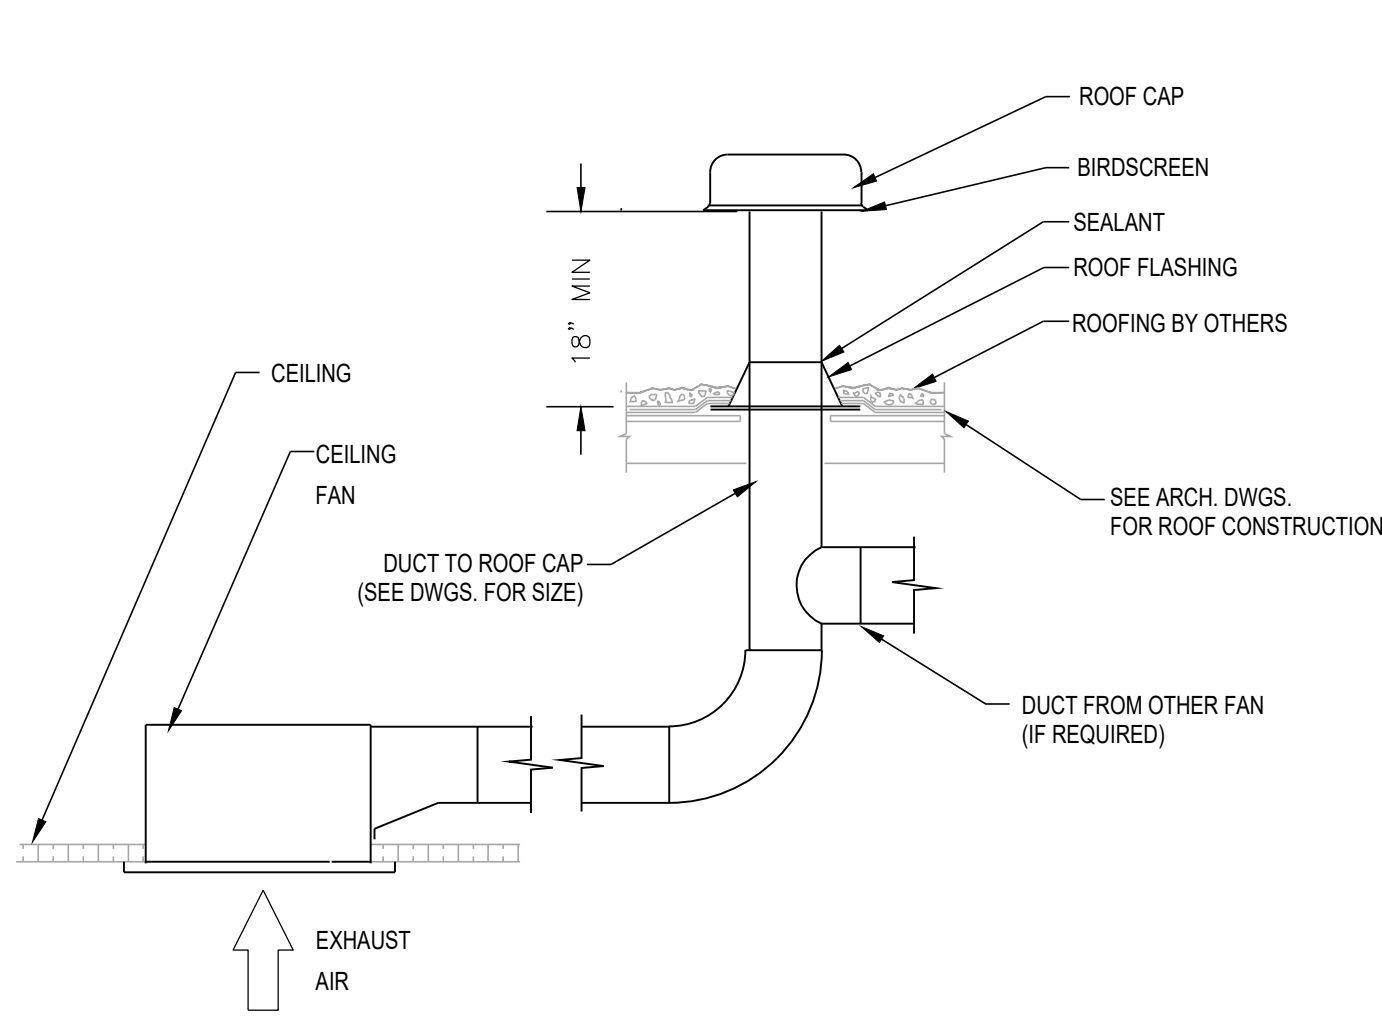


A RESTROOM EXHAUST FAN DETAIL
NTS

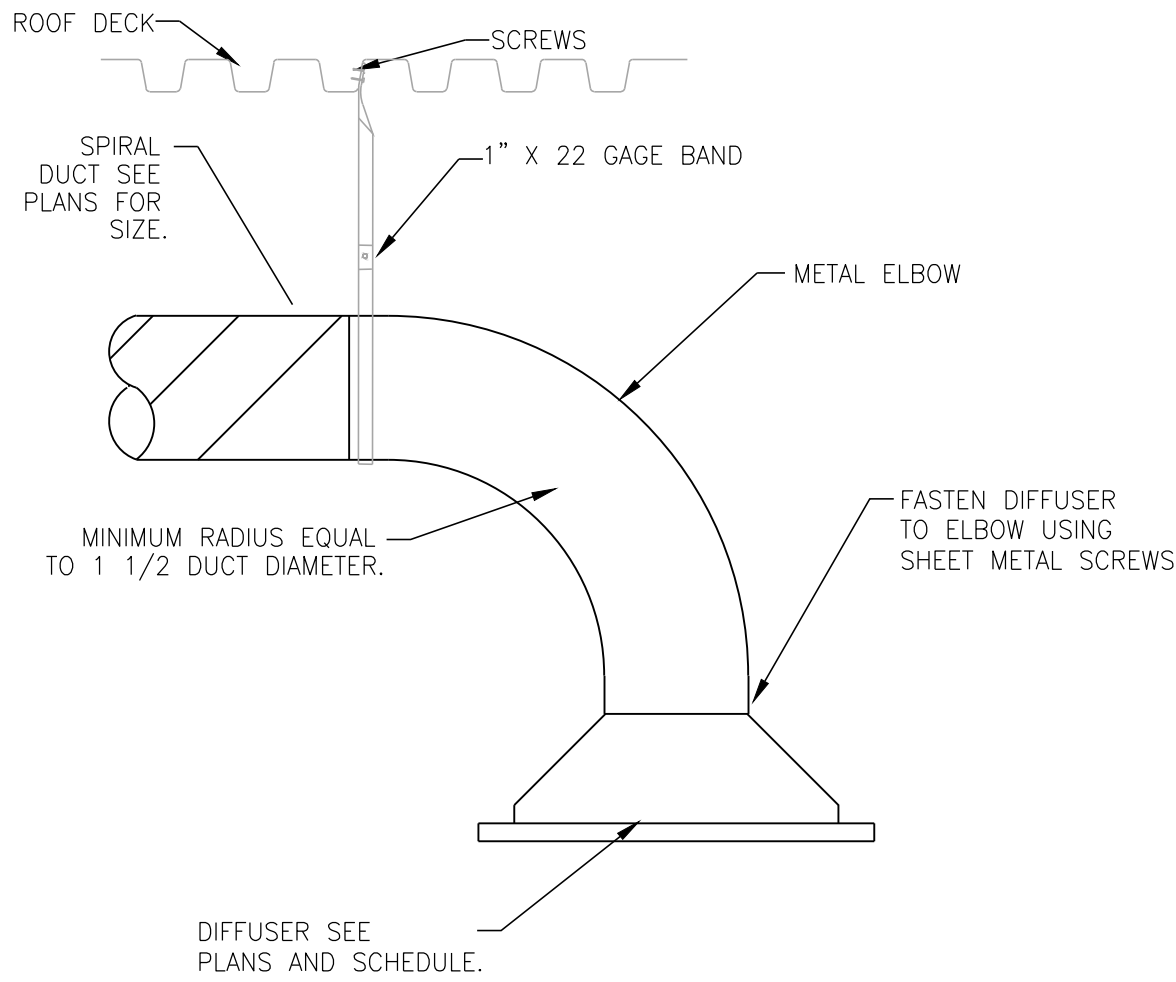

B DUCT MOUNTED DIFFUSER DETAIL
NTS

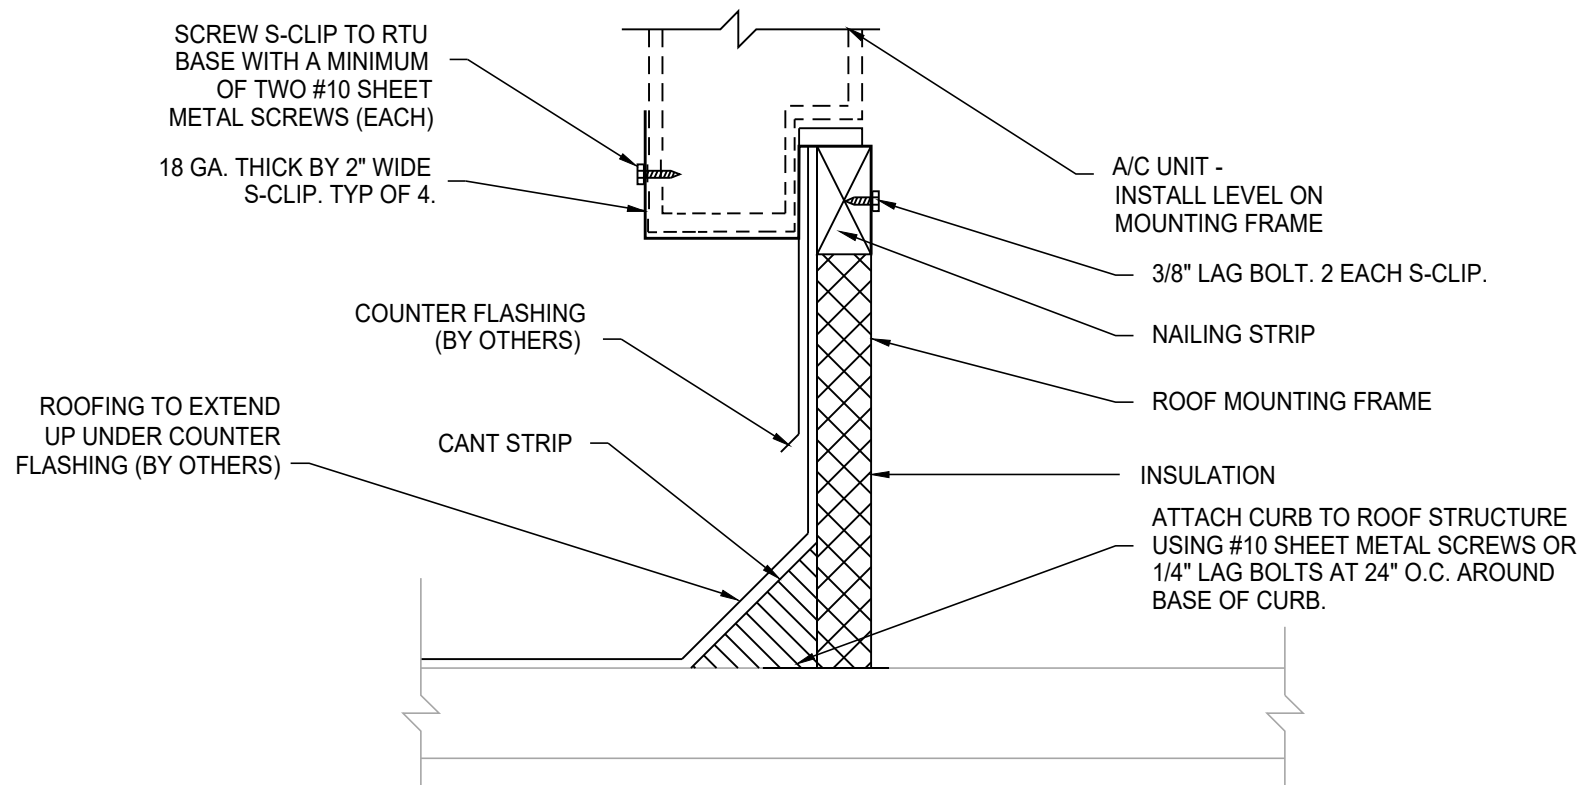

C A/C ROOF CURB DETAIL
NTS

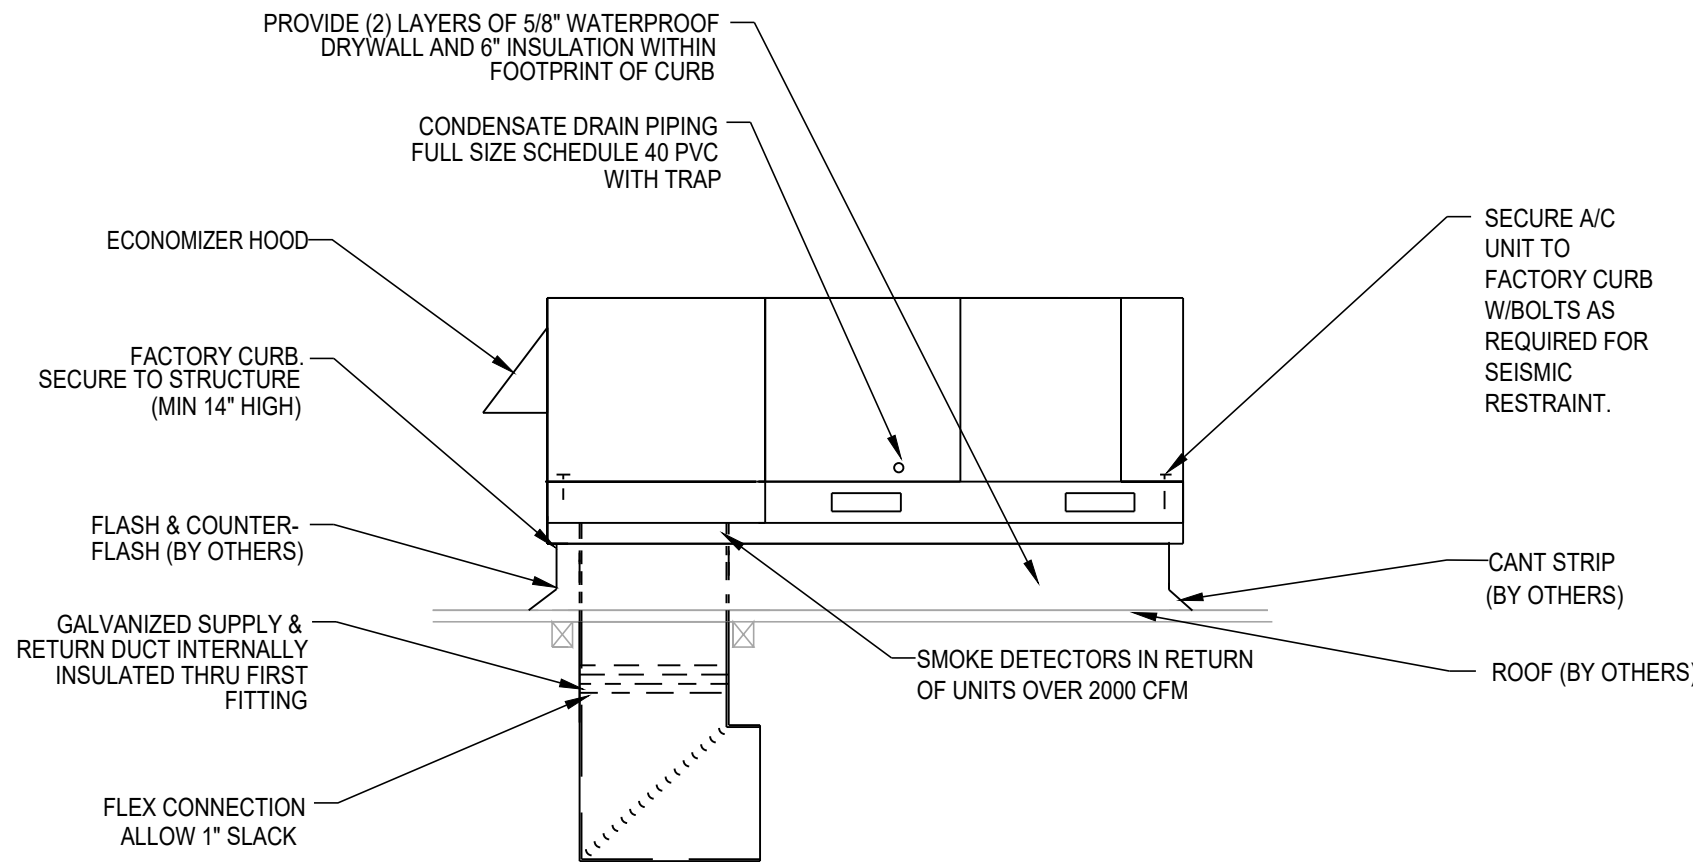

D PACKAGED ROOFTOP UNIT DETAIL
NTS

ROOFTOP UNIT SCHEDULE

TAG	ROOFTOP LOCATION AREA SERVED	COOLING						HEATING		FAN			ELECTRICAL				RT OPER. WEIGHT LBS.	ROOFTOP MANUFACTURER MODEL NUMBER
		TONAGE/ EFF	BTUH		DESIGN COND. deg F DBWB			BTUH		CFM at ?	EXT. SP inches	O.A CFM	POWER V/PH/Hz	MCA	FUSE	DISCON- NECT/ VFD		
			SENSIBLE	TOTAL	EAT	CLAT*	OAT	INPUT	OUTPUT at 4,500'									
RT 1	ROOF MOUNTED -	2.5 14 SEER	-	30,000	80 60	55 -	97 62	75,000	-	1,000	0.5	250	208/1/60	22.8	35	BY EC N/A	550	LENNOX 13GEP30075ALP


1 PROVIDE WITH FACTORY 14" HIGH ROOF CURB, ECONOMIZER, BAROMETRIC RELIEF, 7-DAY PROGRAMMABLE AUTO CHANGE OVER THERMOSTAT AND 2" PLEATED FILTERS. FUTURE UNIT.

EXHAUST FAN SCHEDULE

TAG	EXHAUST FAN LOCATION AREA SERVED	FAN				ELECTRICAL				FAN OPER. WEIGHT LBS.	OPTIONS AND ACCESSORIES	EXHAUST FAN MANUFACTURER MODEL NUMBER
		CFM @ ALT.	ESP INCHES W.C.	FAN WHEEL RPM	SONES/ DB	POWER V/PH/Hz	HP	MOTOR RPM	DISCON- NECT/ STARTER			
EF 1	CEILING MOUNTED RESTROOM	75	0.13	-	-	120/1/60	87W	-	BY EC N/A	25	ON WITH LIGHTS -	BROAN 784

REGISTER, GRILLE, AND DIFFUSER SCHEDULE

TAG	RGD MOUNTING LOCATION RGD USE	RGD BORDER SIZE INCHES	RGD NECK SIZE INCHES	RGD FACE STYLE	CEILING TYPE	RGD AIR PATTERN	RGD CONNECTION SIZE INCHES	RGD FINISH COLOR	OPTIONS AND ACCESSORIES		RGD MANUFACTURER MODEL NUMBER
1 -	CEILING MOUNTED SUPPLY AIR	18"Ø	10"Ø	LOUVER	OPEN CEILING	4 WAY	10"Ø	WHITE	-	-	KRUEGER RM1
2 -	CEILING MOUNTED SUPPLY AIR	15"Ø	8"Ø	LOUVER	OPEN CEILING	4 WAY	8"Ø	WHITE	-	-	KRUEGER RM1
3 -	CEILING MOUNTED SUPPLY AIR	11"Ø	6"Ø	LOUVER	OPEN CEILING	4 WAY	6"Ø	WHITE	-	-	KRUEGER RM1

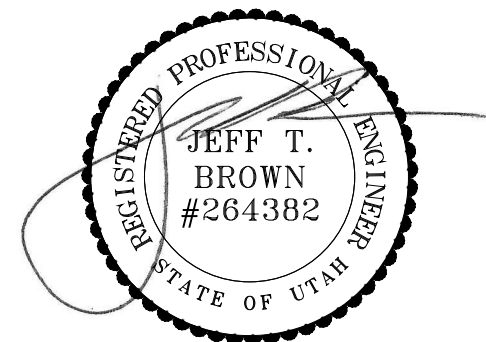

PERMIT SET

REV.	DATE	DESCRIPTION
-	-	-
-	-	-
-	-	-
-	-	-
-	-	-
-	-	-
A	01/19/2018	RELEASED FOR PERMIT

JTB JTB HVAC & Plumbing
Engineering, Inc.
10459 South 1300 West, Suite 203
South Jordan, Utah 84095
WWW.JTBEngineering.net
PH: (801) 849-8590

PROJECT NAME:
**LA CAILLE- BANQUET
SUPPORT REMODEL**

ADDRESS
9565 WASATCH BLVD
SANDY, UT 84092

DRAWING TITLE:
**MECHANICAL
DETAILS AND SCHEDULES**

JOB NO.:	18.005	SHEET NUMBER
DATE:	01/19/2018	M701
DRAWN BY:	JTB	
SCALE:	NTS	